


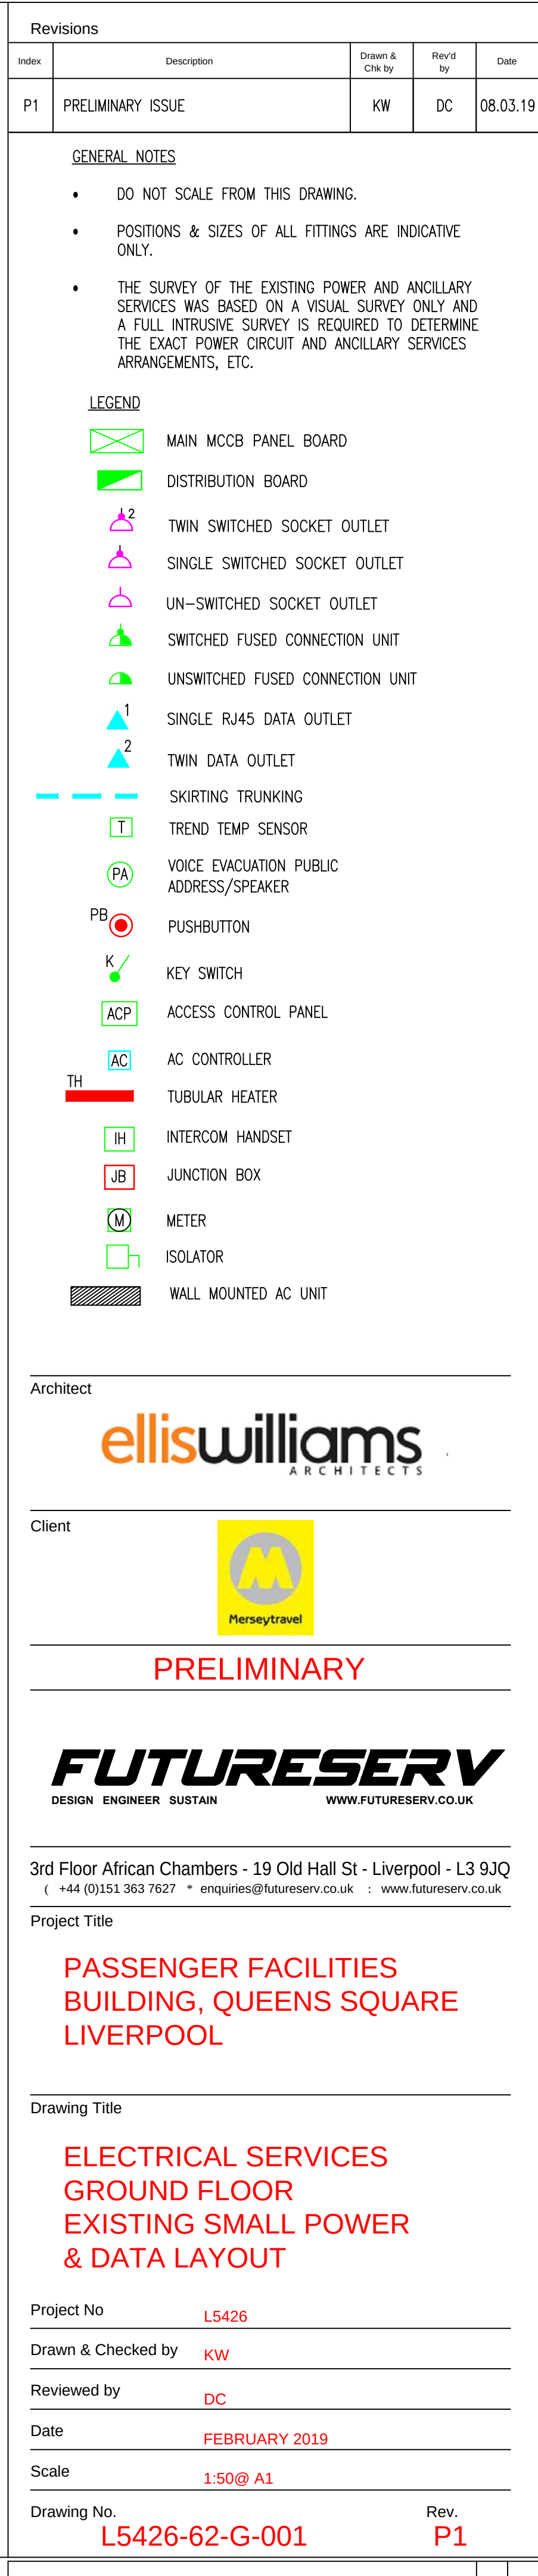

GENERAL NOTES

- DO NOT SCALE FROM THIS DRAWING.
- POSITIONS & SIZES OF ALL FITTINGS ARE INDICATIVE ONLY.
- THE SURVEY OF THE EXISTING POWER AND ANCILLARY SERVICES WAS BASED ON A VISUAL SURVEY ONLY AND A FULL INTRUSIVE SURVEY IS REQUIRED TO DETERMINE THE EXACT POWER CIRCUIT AND ANCILLARY SERVICES ARRANGEMENTS, ETC.

LEGEND

- | | |
|---|---|
|  | MAIN MCCB PANEL BOARD |
|  | DISTRIBUTION BOARD |
|  | TWIN SWITCHED SOCKET OUTLET |
|  | SINGLE SWITCHED SOCKET OUTLET |
|  | UN-SWITCHED SOCKET OUTLET |
|  | SWITCHED FUSED CONNECTION UNIT |
|  | UNSWITCHED FUSED CONNECTION UNIT |
|  | SINGLE RJ45 DATA OUTLET |
|  | TWIN DATA OUTLET |
|  | SKIRTING TRUNKING |
|  | TREND TEMP SENSOR |
|  | VOICE EVACUATION PUBLIC ADDRESS/SPEAKER |
|  | PUSHBUTTON |
|  | KEY SWITCH |
|  | ACCESS CONTROL PANEL |
|  | AC CONTROLLER |
|  | TUBULAR HEATER |
|  | INTERCOM HANDSET |
|  | JUNCTION BOX |
|  | METER |
|  | ISOLATOR |
|  | WALL MOUNTED AC UNIT |

Architect

elliswilliams
ARCHITECTS

Client



PRELIMINARY

FUTURESERV
DESIGN ENGINEER SUSTAIN WWW.FUTURESERV.CO.UK

3rd Floor African Chambers - 19 Old Hall St - Liverpool - L3 9JQ
(+44 (0)151 363 7627 * enquiries@futureserv.co.uk : www.futureserv.co.uk

Project Title

PASSENGER FACILITIES BUILDING, QUEENS SQUARE LIVERPOOL

Drawing Title

ELECTRICAL SERVICES GROUND FLOOR EXISTING SMALL POWER & DATA LAYOUT

Project No L5426

Drawn & Checked by **KW**

Reviewed by DC

Date FEBRUARY 2019

Scale 1:50@ A1

Drawing No.	Rev.
L5426-62-G-001	P1

FLOOR LEVEL:

- Existing GF Plan

—

—

—

BACKGROUND: OBASE-2115-X(04) EXISTING GF PLAN REV_E
RECEIVED 11-02-2018