
 


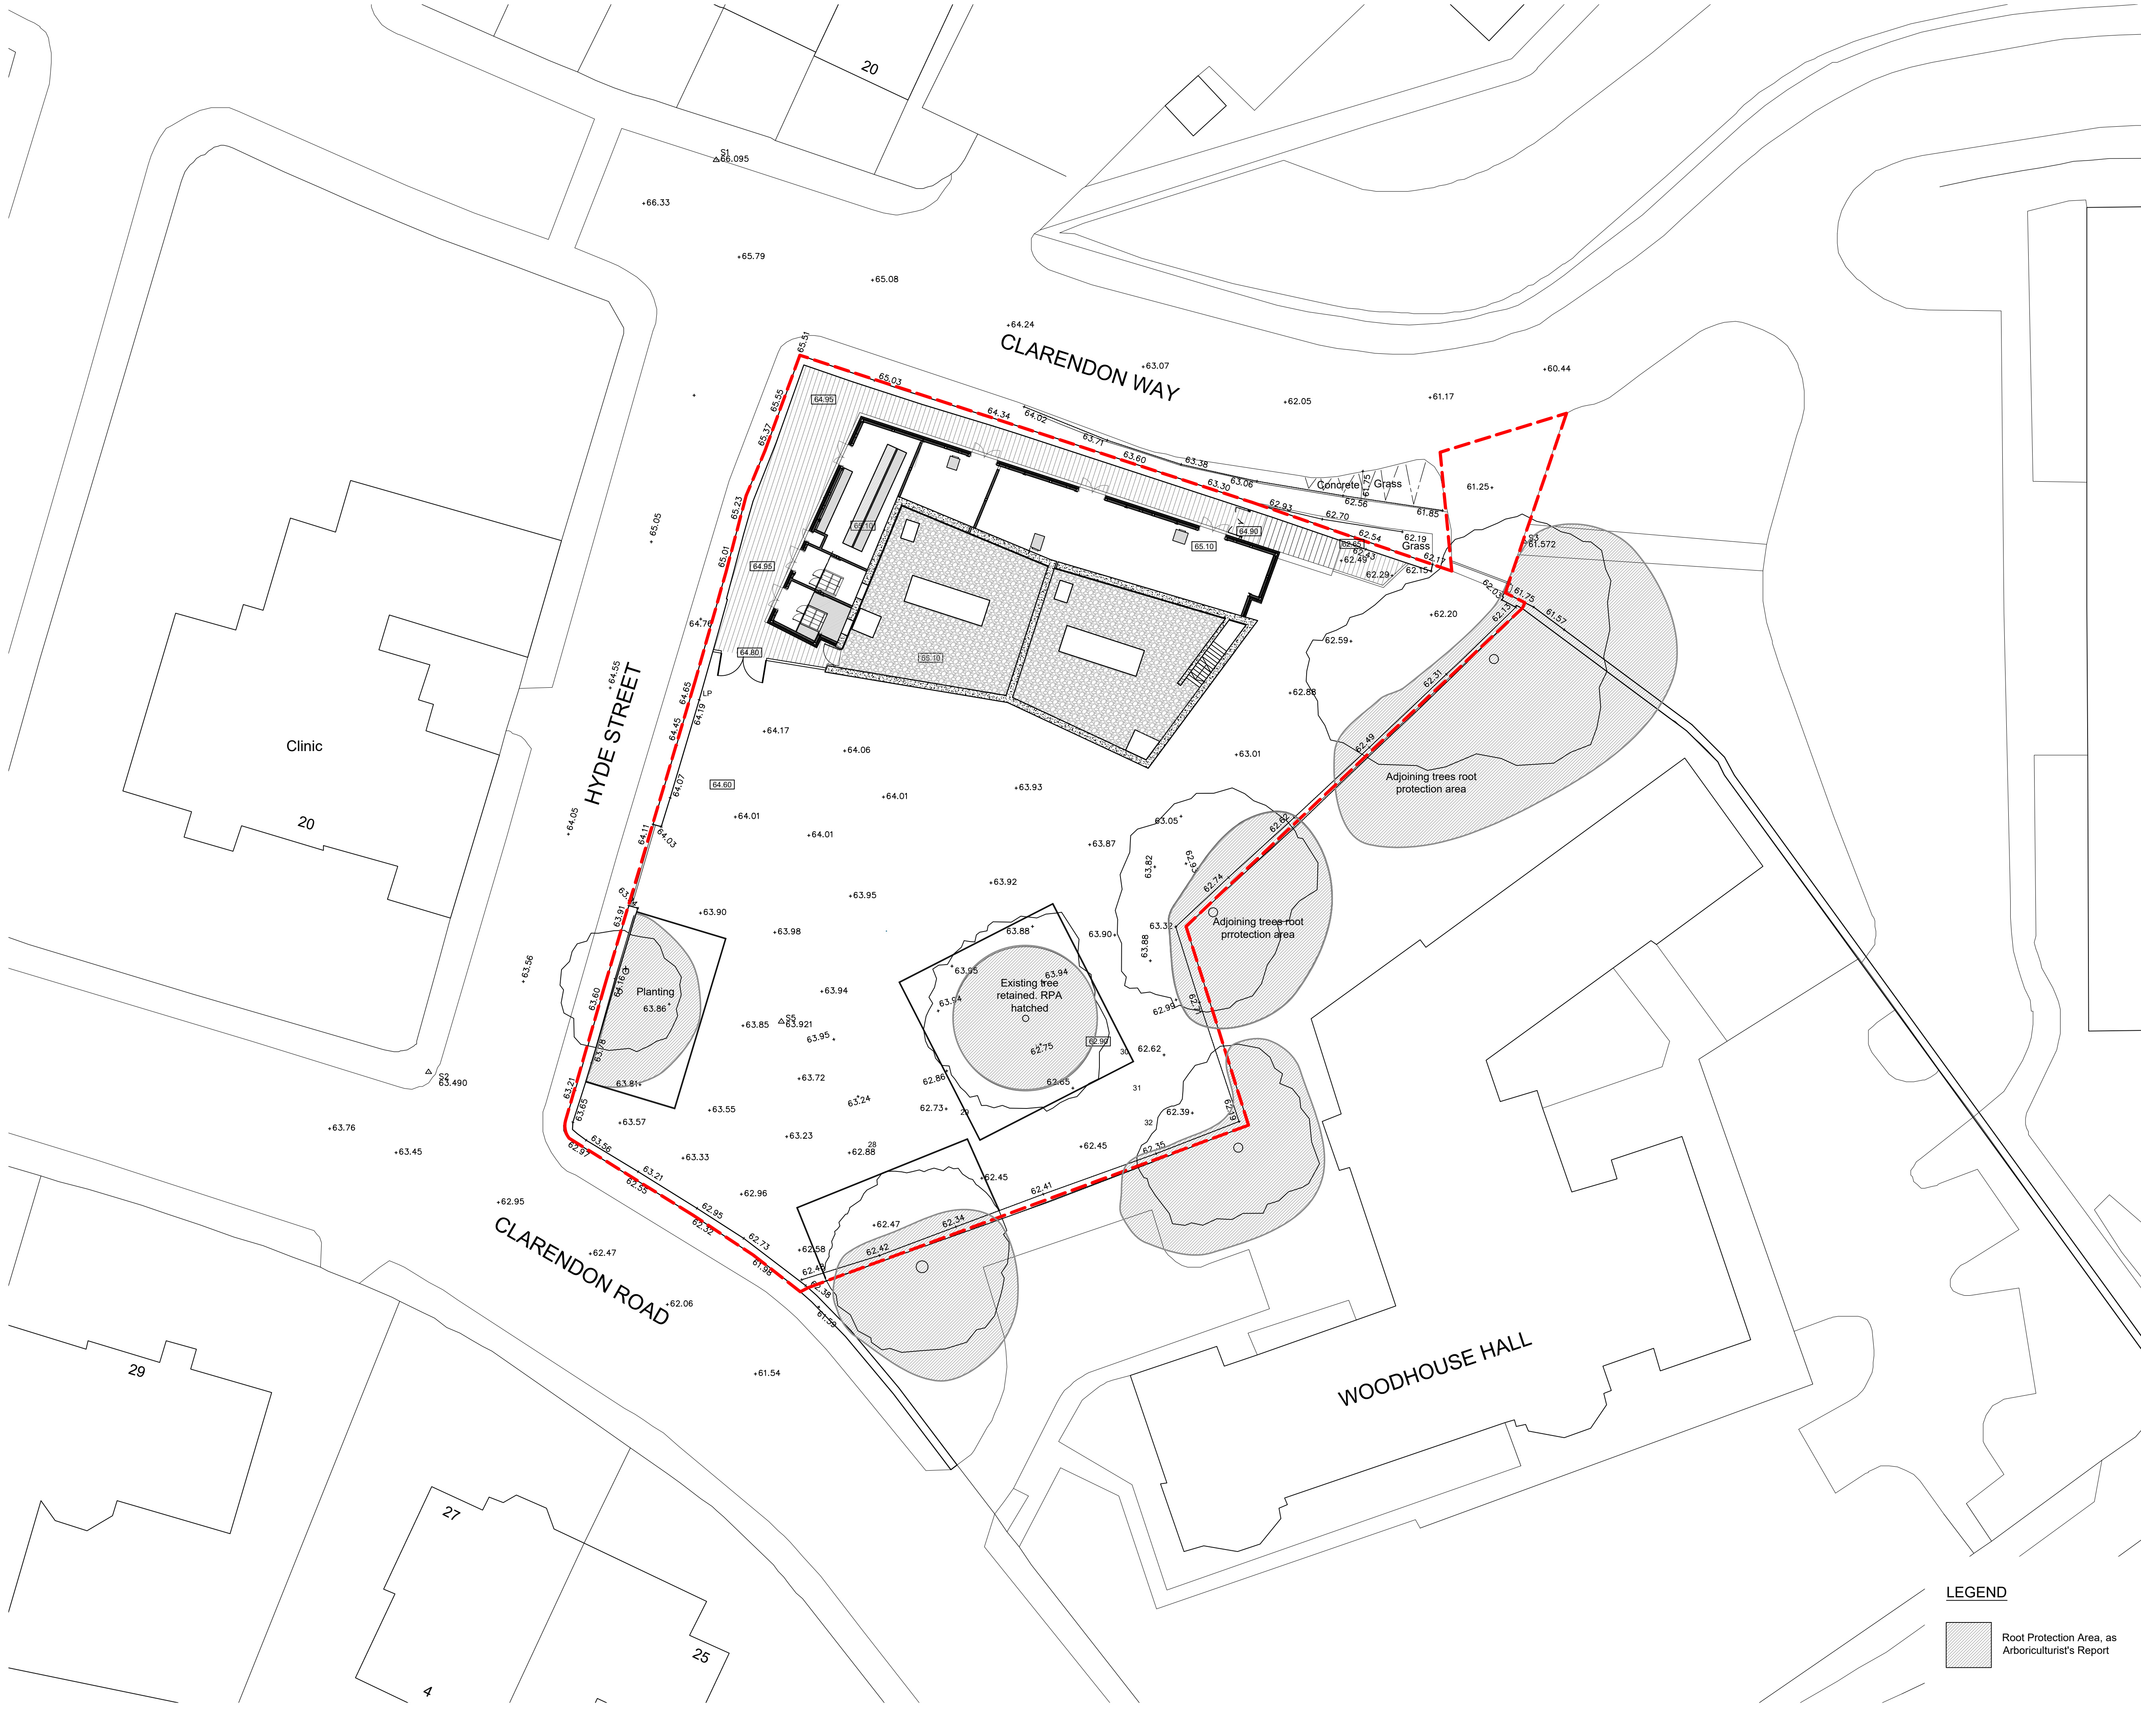

Rev	Description	Date	By
T01	Issued for Tender	17.09.21	IW

Construction Design Management Regulations 2015



Status: **Tender**
Client: **Leeds Teaching Hospitals NHS Trust**

 
Project: **Hospital Substation Car Park**

Title: **Existing Site Plan**

Drawing No.: **492001-FCA-XX-ZZ-DR-A-0102** Rev.: **T01**

Scale: **1:200 @ A1** Date: **July 2021**
Drawn: **IW** Check: **PJ**

LEGEND

 Root Protection Area, as
Arboriculturist's Report

Farrell & Clark
Architects

Leeds
0113 259 0922
leeds@farrellandclark.co.uk
www.farrellandclark.co.uk

London
020 7580 9210
london@farrellandclark.co.uk