
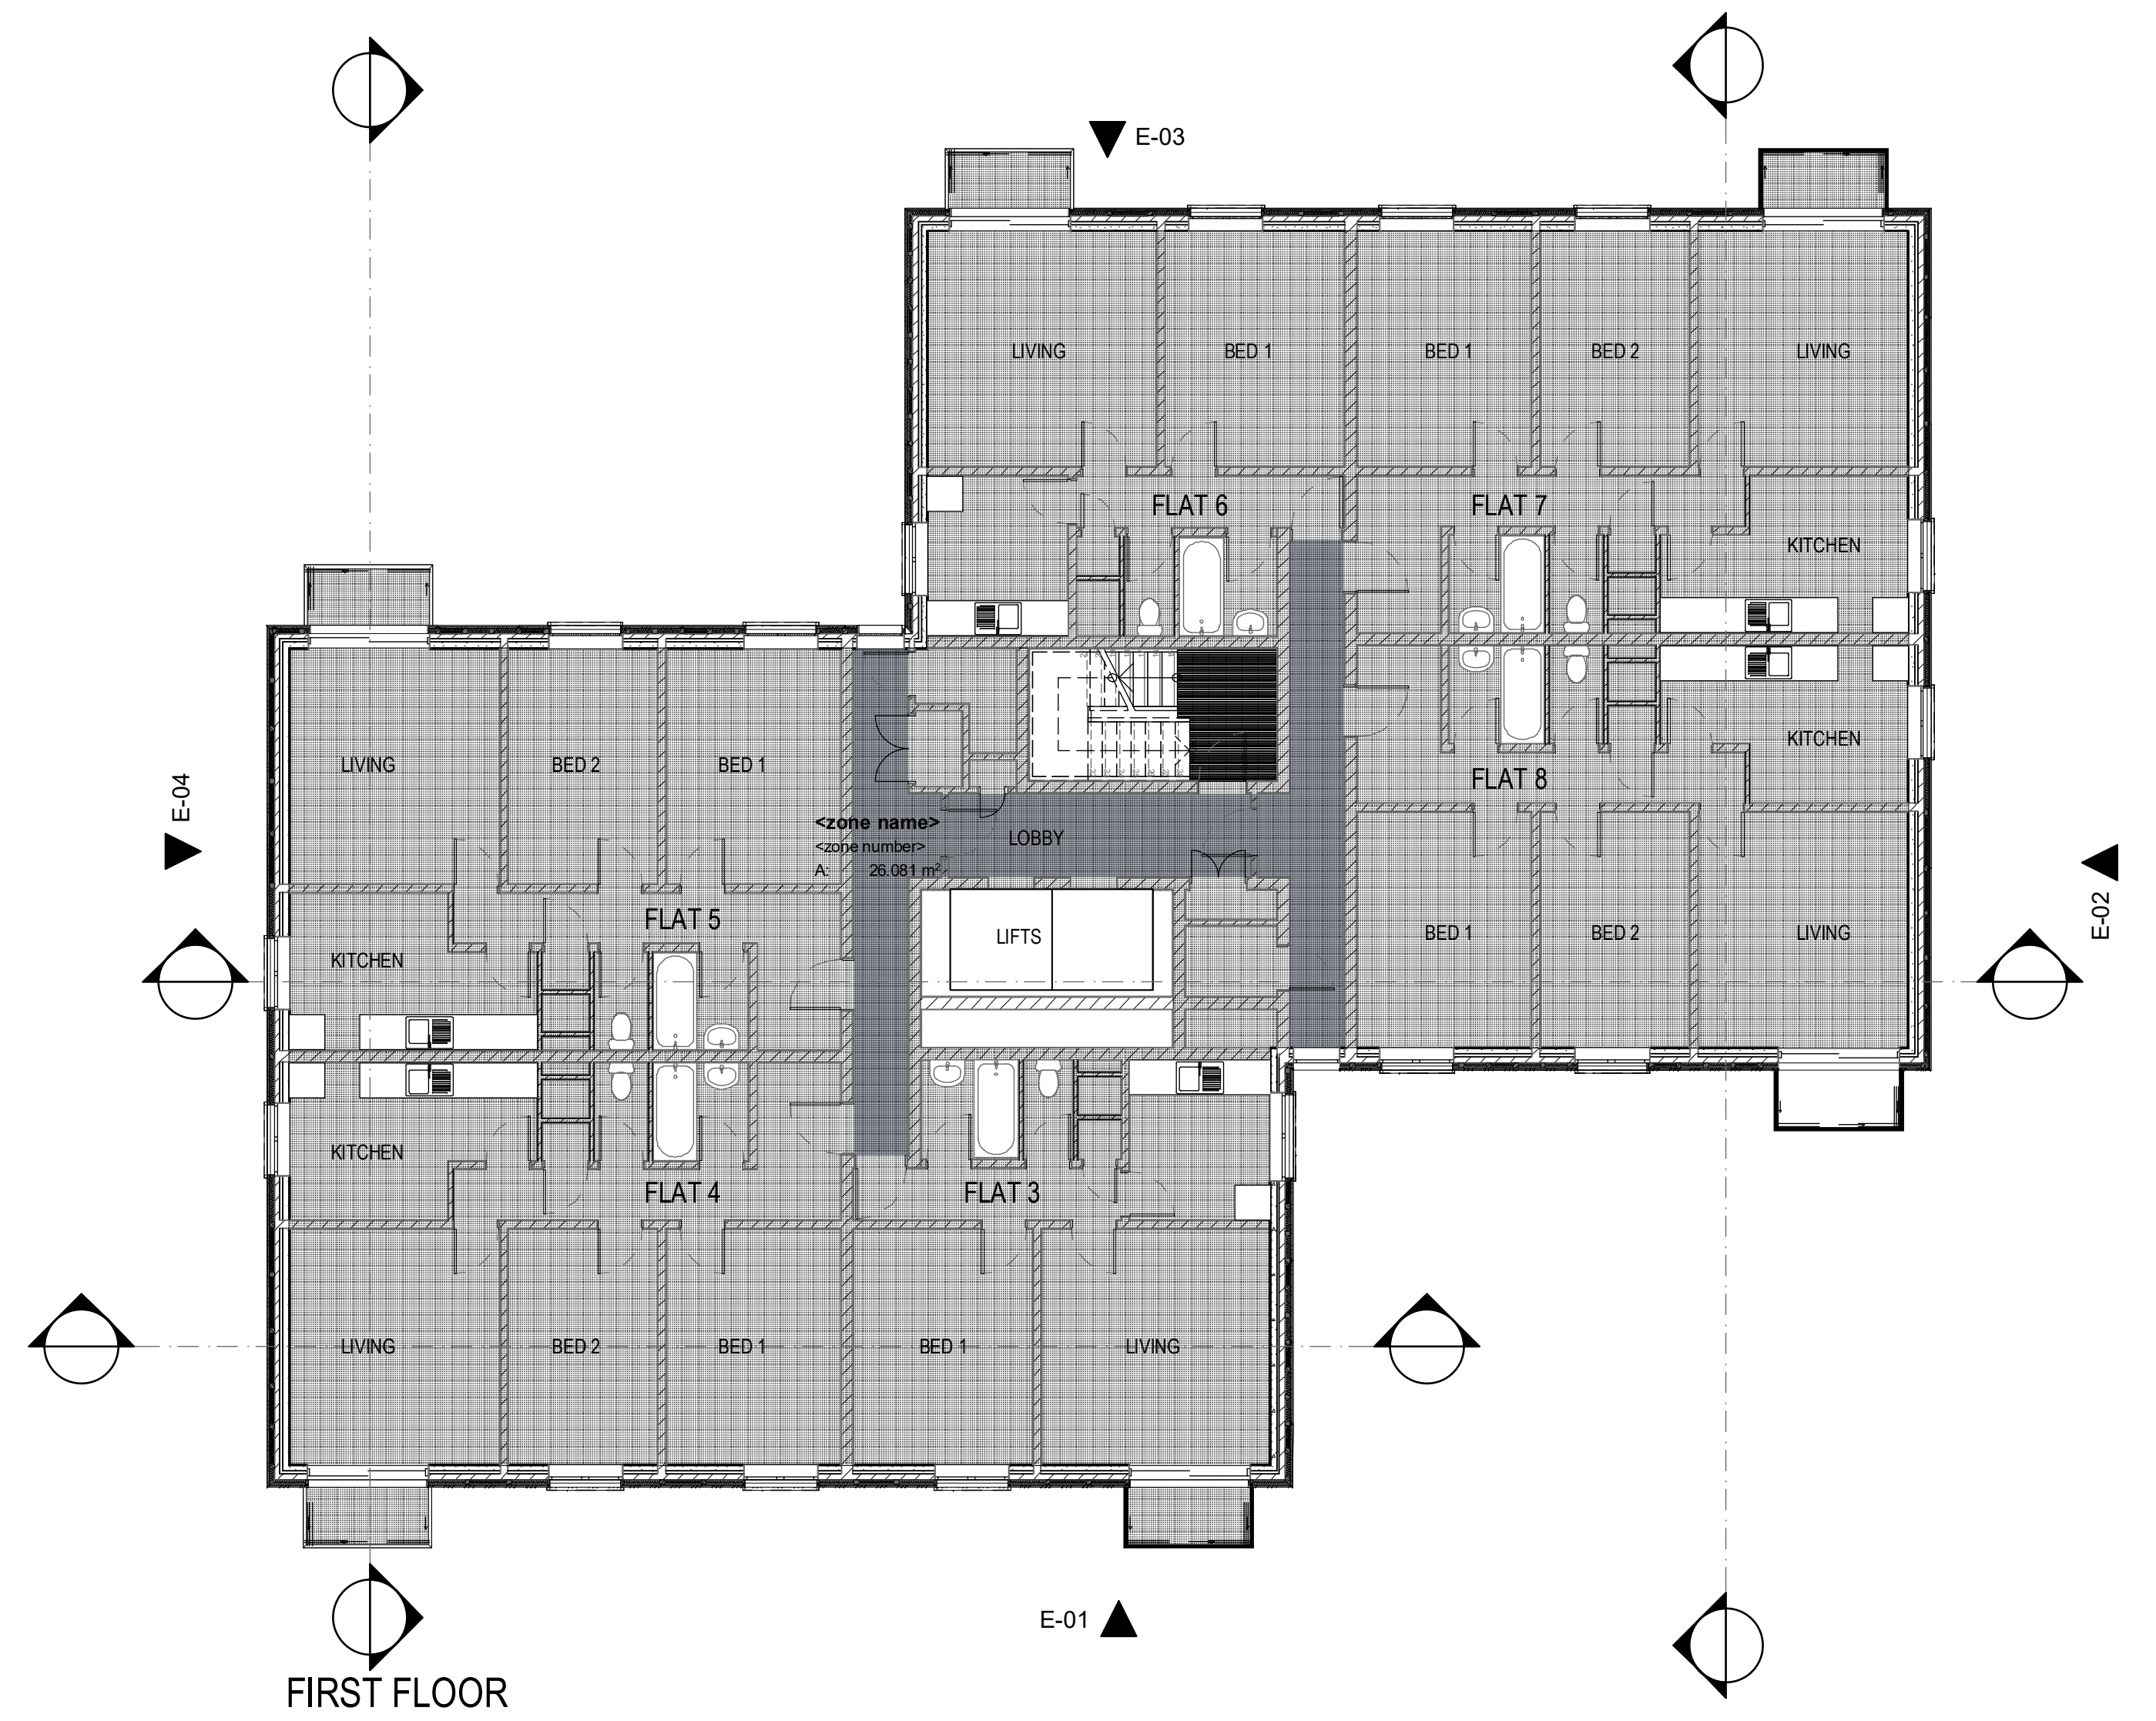


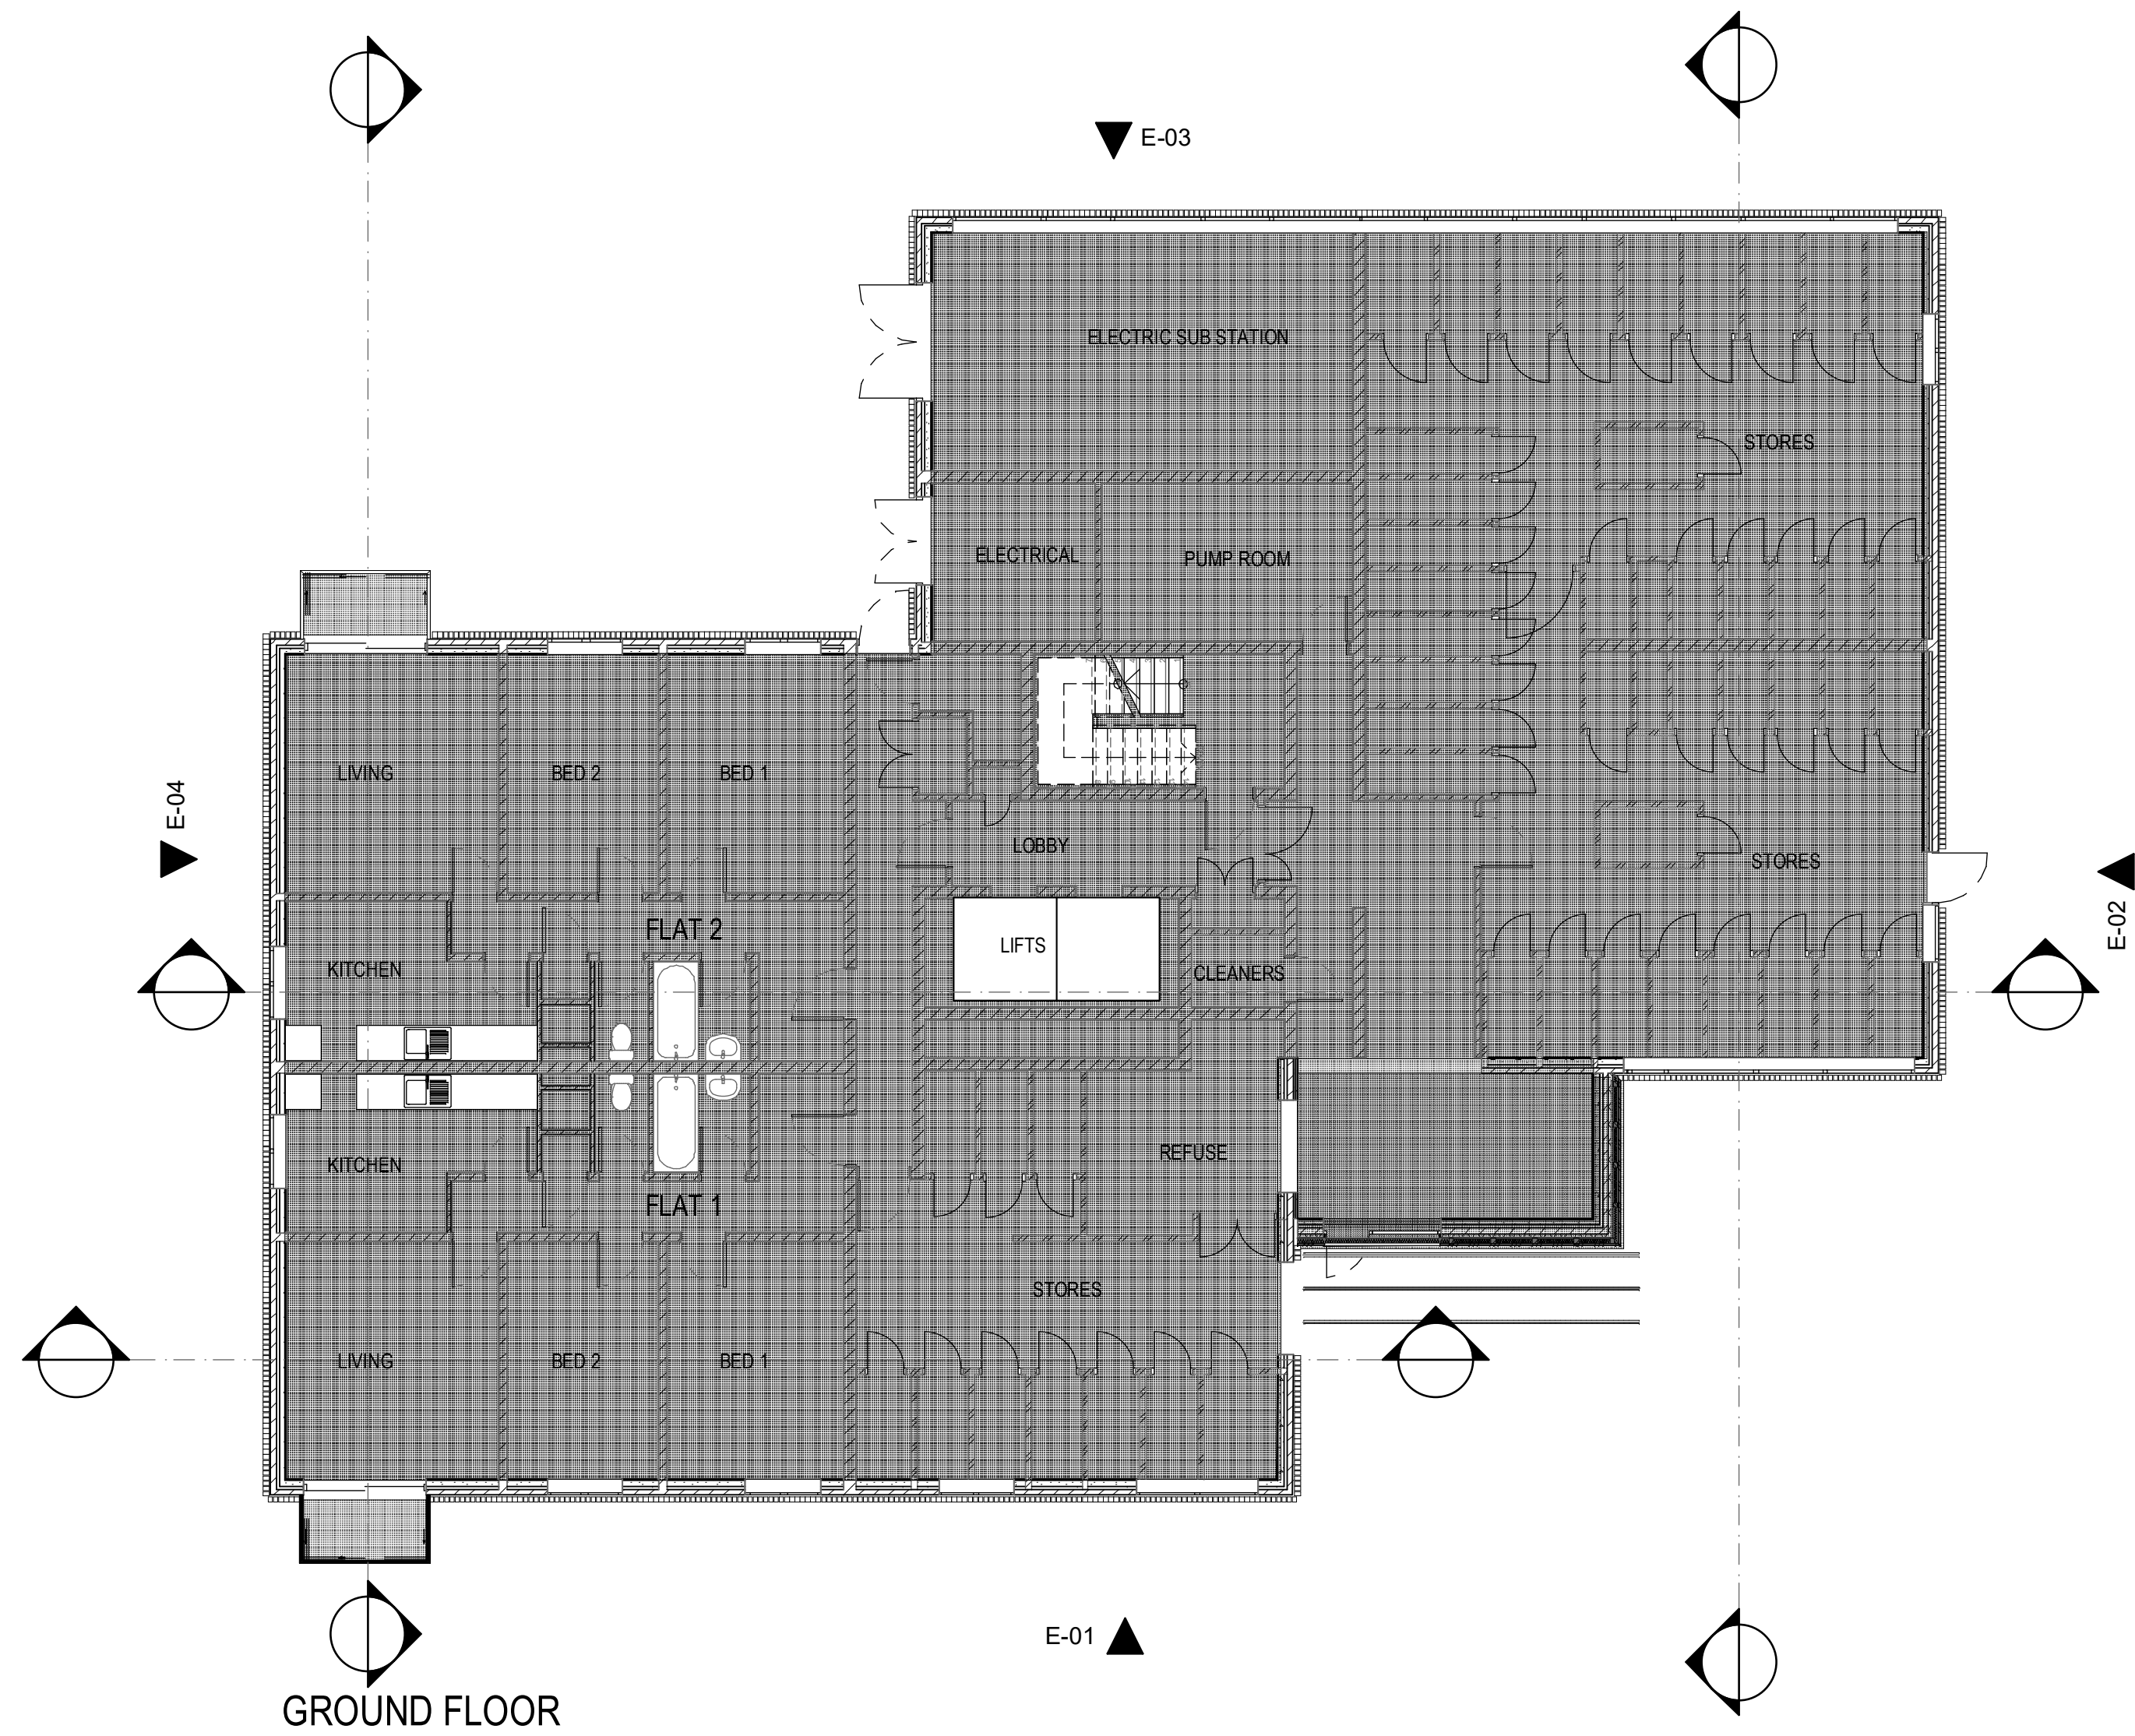

Arcus Consulting LLP
Wakefield 0192 466 9000 Manchester 0161 905 3222 London 020 8742 2512
Liverpool 0151 708 1080 Newcastle 0191 280 4000 info@arcus.uk.com
www.arcus.uk.com

Client
POOLE HOUSING PARTNERSHIP

Project
PROJECT ADMIRAL
POOLE

Title
DRAKE COURT
PROPOSED GROUND & FIRST FLOOR PLAN

Scale	Date	Stage
1:100 @ A1	06/06/18	2
Job No	Drawing No	Rev
5131	Sk 30.001	.
Drawn	Approved	
PDS	.	

This drawing is the copyright of Arcus. Contractors must check all dimensions on site. Do not scale the drawings. Only figured dimensions are to be worked to.