


- Notes**
1. Roadway and footpath surfacing design and construction to Engineer's Specification (by others).
 2. Heavy duty geotextile fleece to be non-woven needle-punched polypropylene as per Specification. Geotextile to be laid with minimum 300mm overlaps and to be applied to all external surfaces of Polypipe Permeable drainage units. To be installed in accordance with the manufacturer's recommendations.
 3. Waterproof geomembrane to be single layer cold applied robust welded flexible membrane as per Specification suitable for waterproofing to structures and for water containment. Membrane to be nominal 1mm thick laid with minimum 120mm laps and welded seams. To be installed in accordance with the manufacturer's recommendations under and approved CDA protocol that includes testing of the welds.
 4. All dimensions are in millimetres unless otherwise stated.
 5. Pre-cast concrete products shall comply with the relevant provisions of BS 5911 and be '10m Marked'.
 6. All pipes and pipe fittings shall be HDPE twinwall and have current British Board of Agreement Certification.
 7. Manhole covers and frames, grids and frames shall comply with the relevant provisions of BS EN 124.
 8. Do not scale from this drawing. If in doubt ask.
 9. This drawing to be read in conjunction with all relevant EPG Architects & Engineers drawings.
 10. Should there be any conflict between the details indicated on this drawing and those on other drawings the Engineer should be informed PRIOR to construction on site.
 11. UNLESS TECHNICAL APPROVAL HAS BEEN OBTAINED FROM THE RELEVANT AUTHORITY, IT SHOULD BE UNDERSTOOD THAT ALL DRAWINGS ARE PRELIMINARY AND NOT FOR CONSTRUCTION.
 12. At all times the works are to be executed in accordance with the requirements of the Health And Safety at Work Act 1974 and CDM Regulations 2015.

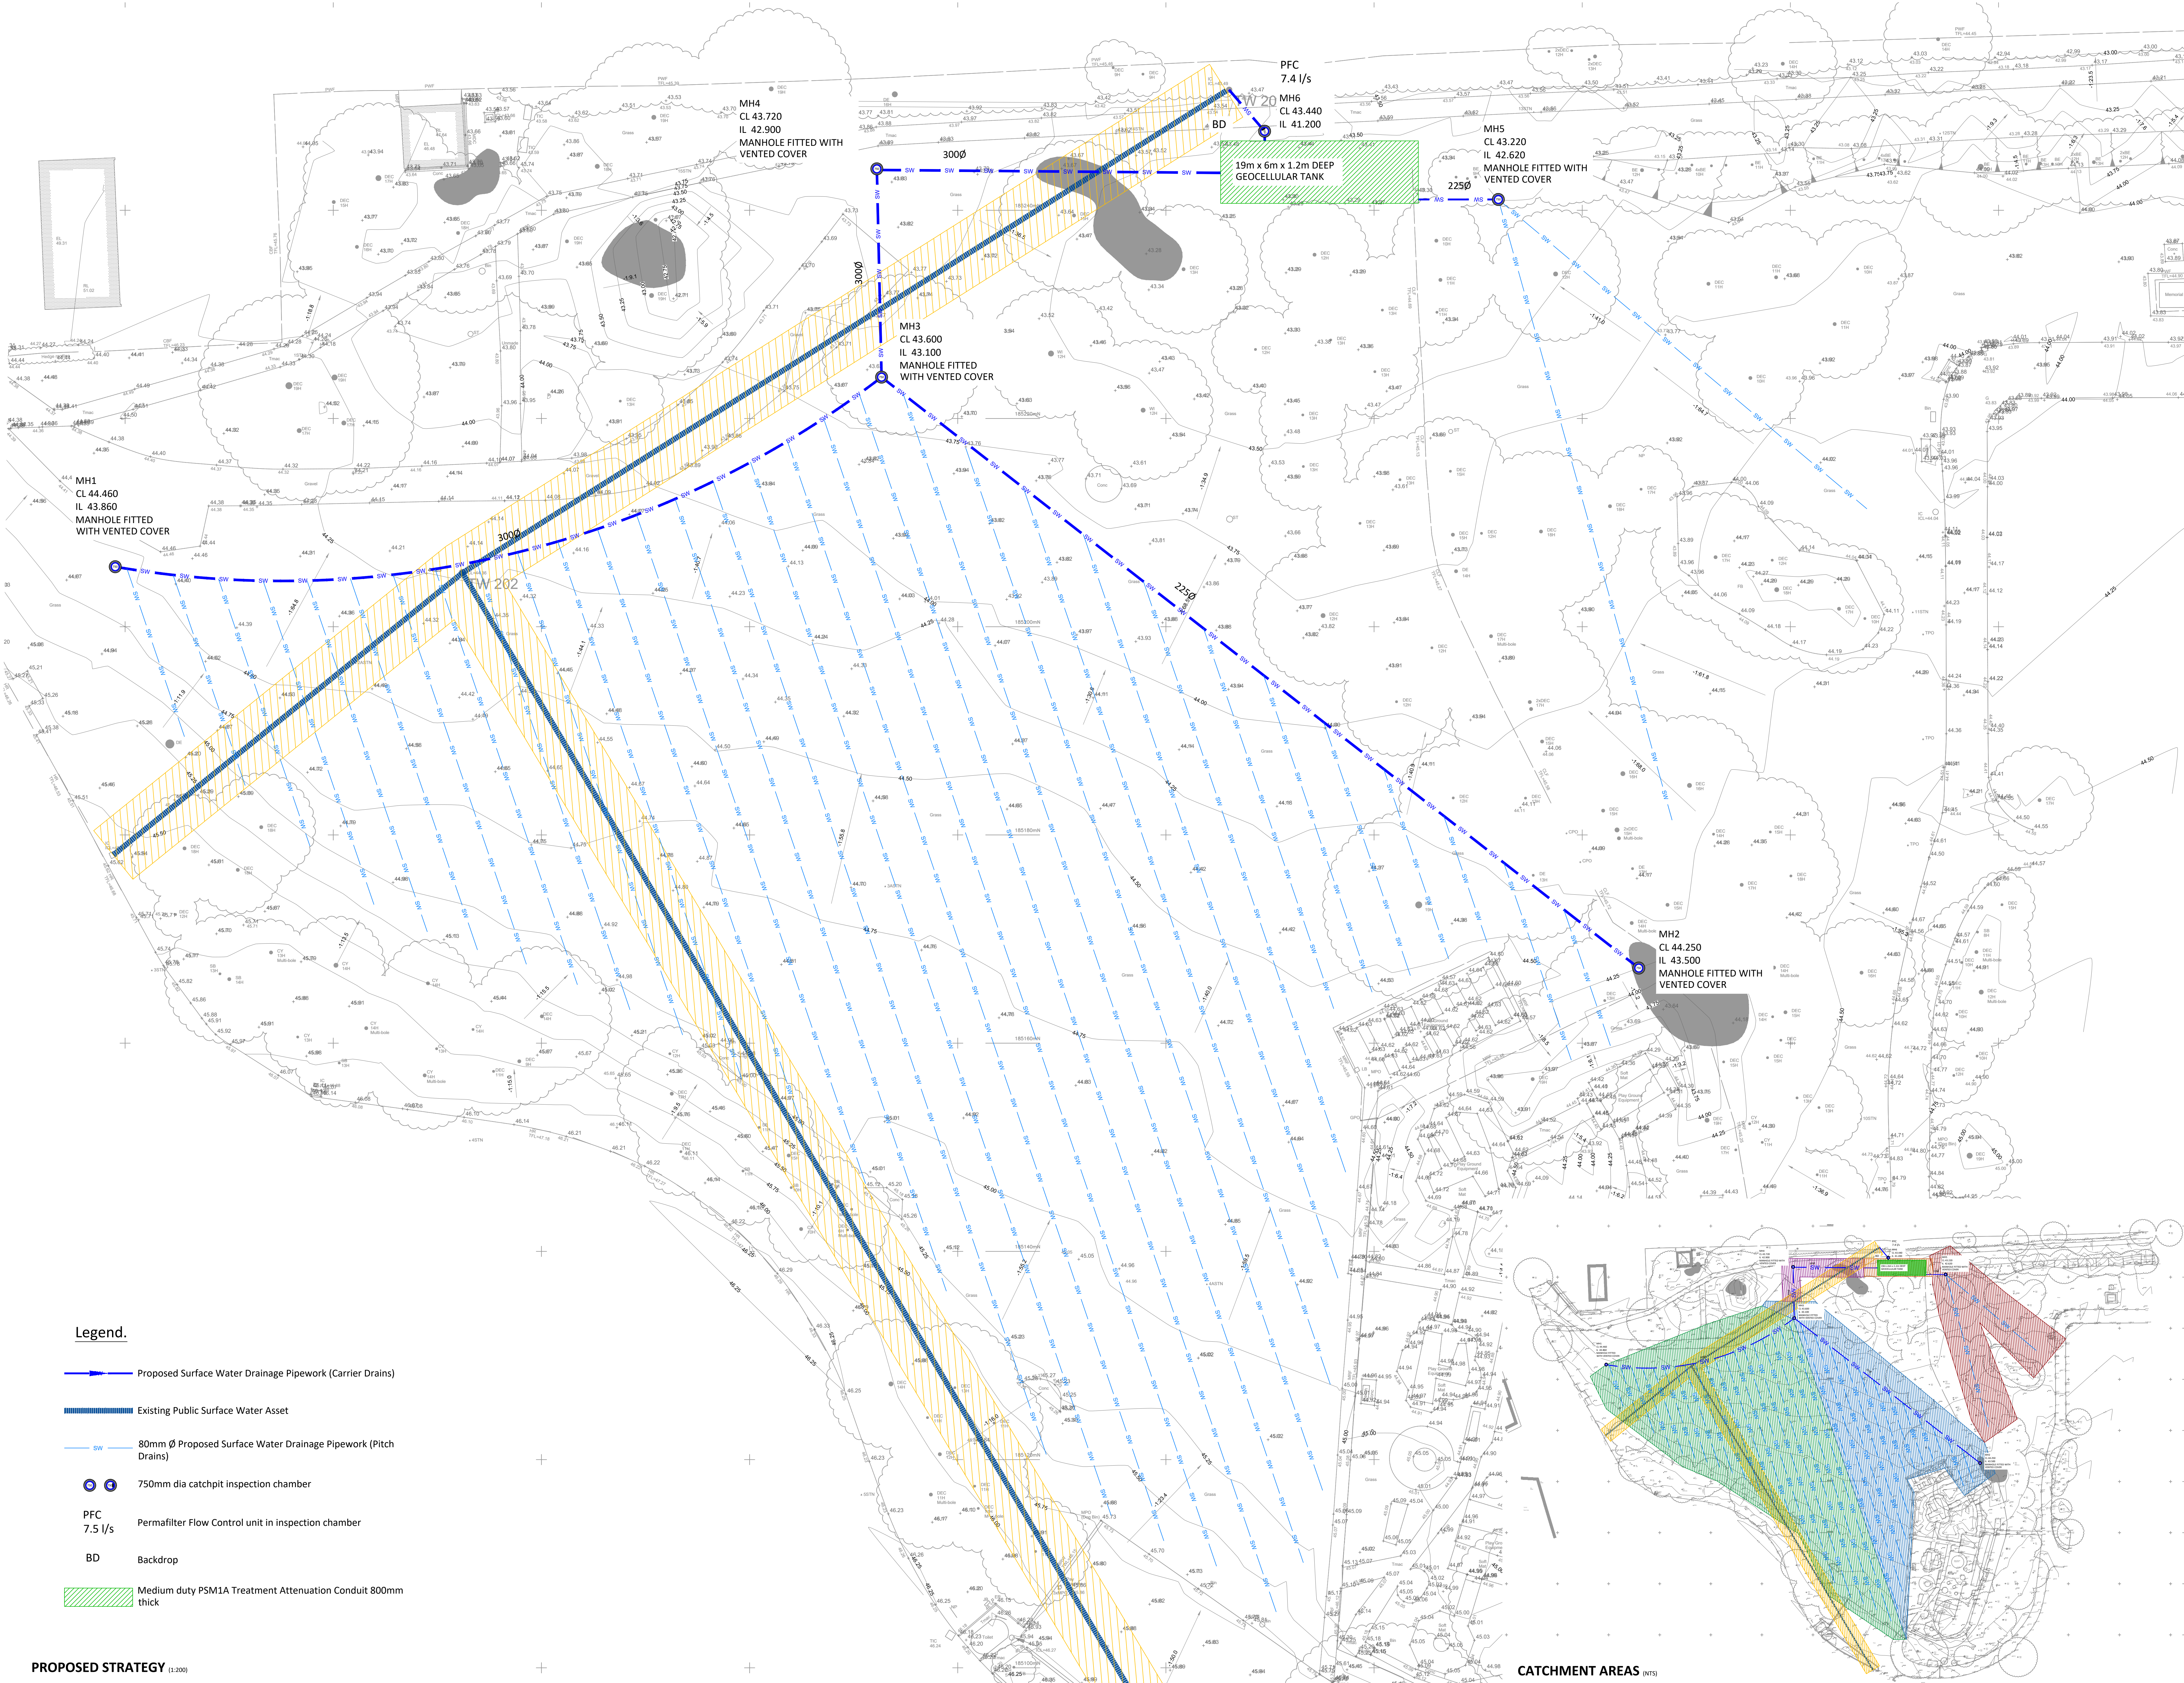

epg Warrington Business Park
Warrington, Cheshire WA1 4JF
T: 01524 622 980 F: 01524 622 983
W: www.epg.co.uk E: enquiries@epg.co.uk
The Environmental Protection Group Ltd
100 Environmental Protection Group Ltd

PROJECT
BARHAM PARK
WEMBLEY

CLIENT
STRI

REV	DESCRIPTION	DATE

DRAWING TITLE
SUSTAINABLE DRAINAGE LAYOUT & DETAILS

SCALE	DATE
1:200	21/02/2020

DRAWN BY	CHECKED BY	STATUS
JHR	PC	FOR COMMENT

9091-EPG-ZZ-XX-DR-Y-0001