


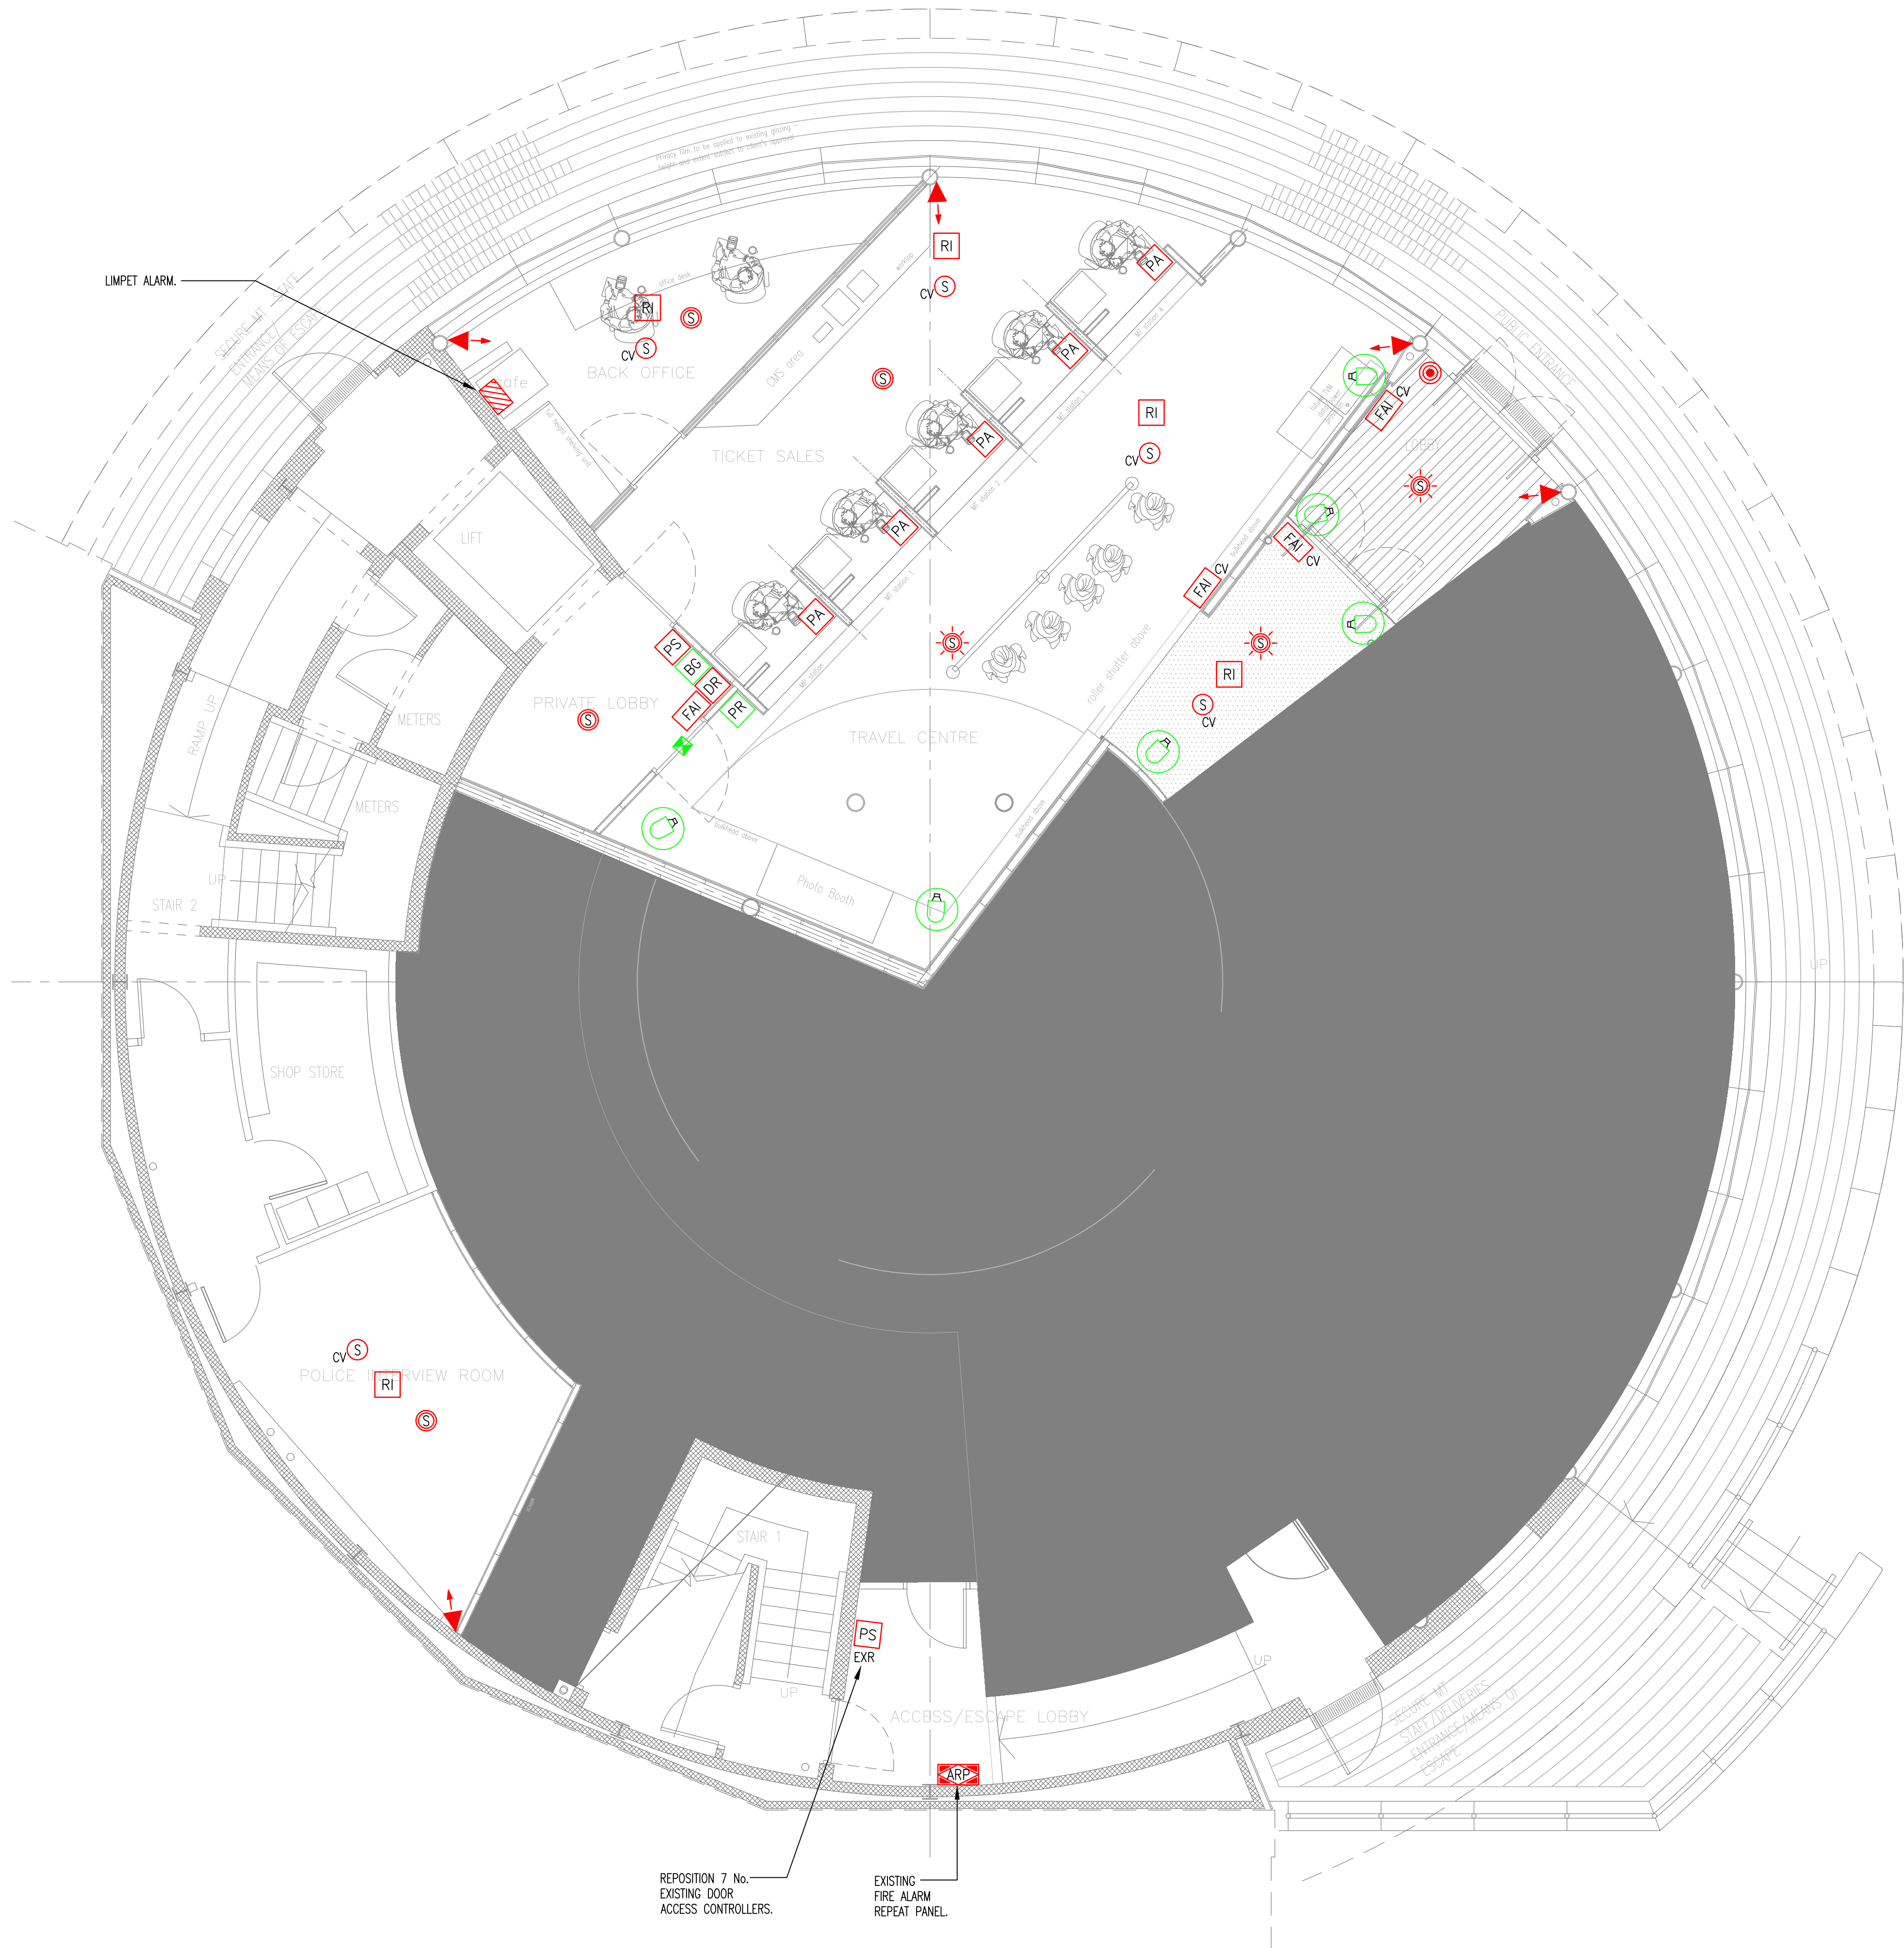

LEGEND

- MAIN FIRE ALARM CONTROL PANEL
- FIRE ALARM REPEATER PANEL
- SMOKE DETECTOR
- SMOKE DETECTOR WITH SOUNDER BASE
- SMOKE DETECTOR WITH SOUNDER BASE & XENON BEACON
- HEAT DETECTOR
- FIRE ALARM CALL POINT
- PIR MOVEMENT DETECTOR
- EMERGENCY GREEN BREAKGLASS UNIT
- PROXIMITY CARD READER
- DOOR RELEASE
- MAGLOCK
- PANIC ALARM BUTTON
- REMOTE FIRE ALARM INDICATOR
- DOOR ACCESS CONTROLLER
- FIRE ALARM INTERFACE UNIT
- ADT ELECTRONIC SOUNDER
- CCTV CAMERA
- CCTV CAMERA - DOME
- CEILING VOID
- DENOTES EXISTING
- DENOTES EXISTING REPOSITIONED

Revisions				
Index	Description	Drawn & Ck'd by	Rev'd by	Date
P1	PRELIMINARY	KW	DC	08.03.19

- GENERAL NOTES
- DO NOT SCALE FROM THIS DRAWING.
 - POSITIONS & SIZES OF ALL FITTINGS ARE INDICATIVE ONLY. PROJECT DESIGN IS DESIGN AND BUILD, CONTRACTOR TO CONFIRM & VALIDATE THE DESIGN AT TENDER STAGE & PRICE AS REQUIRED TO DELIVER THE EMPLOYERS REQUIREMENTS AND PERFORMANCE SPECIFICATION.
 - THE CONTRACTOR SHALL ALLOW FROM DEVELOPING THE DESIGN FROM STAGE 3 THROUGH TO PROJECT COMPLETION.
 - THIS DRAWING SHALL BE READ IN CONJUNCTION WITH ALL OTHER DOCUMENTATION RELEVANT TO THIS PROJECT.
 - CONTRACTORS SHALL CONFIRM THE SEQUENCE OF INSTALLATION WORKS TO ENSURE SAFE ACCESS IS MAINTAINED.
 - ATTENTION IS DRAWN TO HEALTH & SAFETY ISSUES, LIAISE WITH MAIN CONTRACTOR TO ENSURE THAT THE INSTALLATION WORKS ARE PROGRAMMED TO MINIMISE H&S RISKS AND OPTIMISE COORDINATION.

Architect

elliswilliams
ARCHITECTS

Client

Merseytravel

PRELIMINARY

FUTURESERV
DESIGN ENGINEER SUSTAIN
WWW.FUTURESERV.CO.UK

3rd Floor African Chambers - 19 Old Hall St - Liverpool - L3 9JQ
(+44 (0)151 363 7627 * enquires@futureserv.co.uk : www.futureserv.co.uk)

Project Title

**PASSENGER FACILITIES
BUILDING, QUEENS SQUARE
LIVERPOOL**

Drawing Title

**ELECTRICAL SERVICES
GROUND FLOOR
PROPOSED FIRE ALARM &
SECURITY LAYOUT**

Project No **L5426**

Drawn & Checked by **KW**

Reviewed by **DC**

Date **MARCH 2019**

Scale **1:50@ A1**

Drawing No. **L5426-67-G-002**

Rev. **P1**

FLOOR LEVEL:
- Proposed GF Plan
-
-
-
BACKGROUND: CBSE-2115-X(04) PROPOSED GF PLAN REV.L
RECEIVED 07-03-2019