
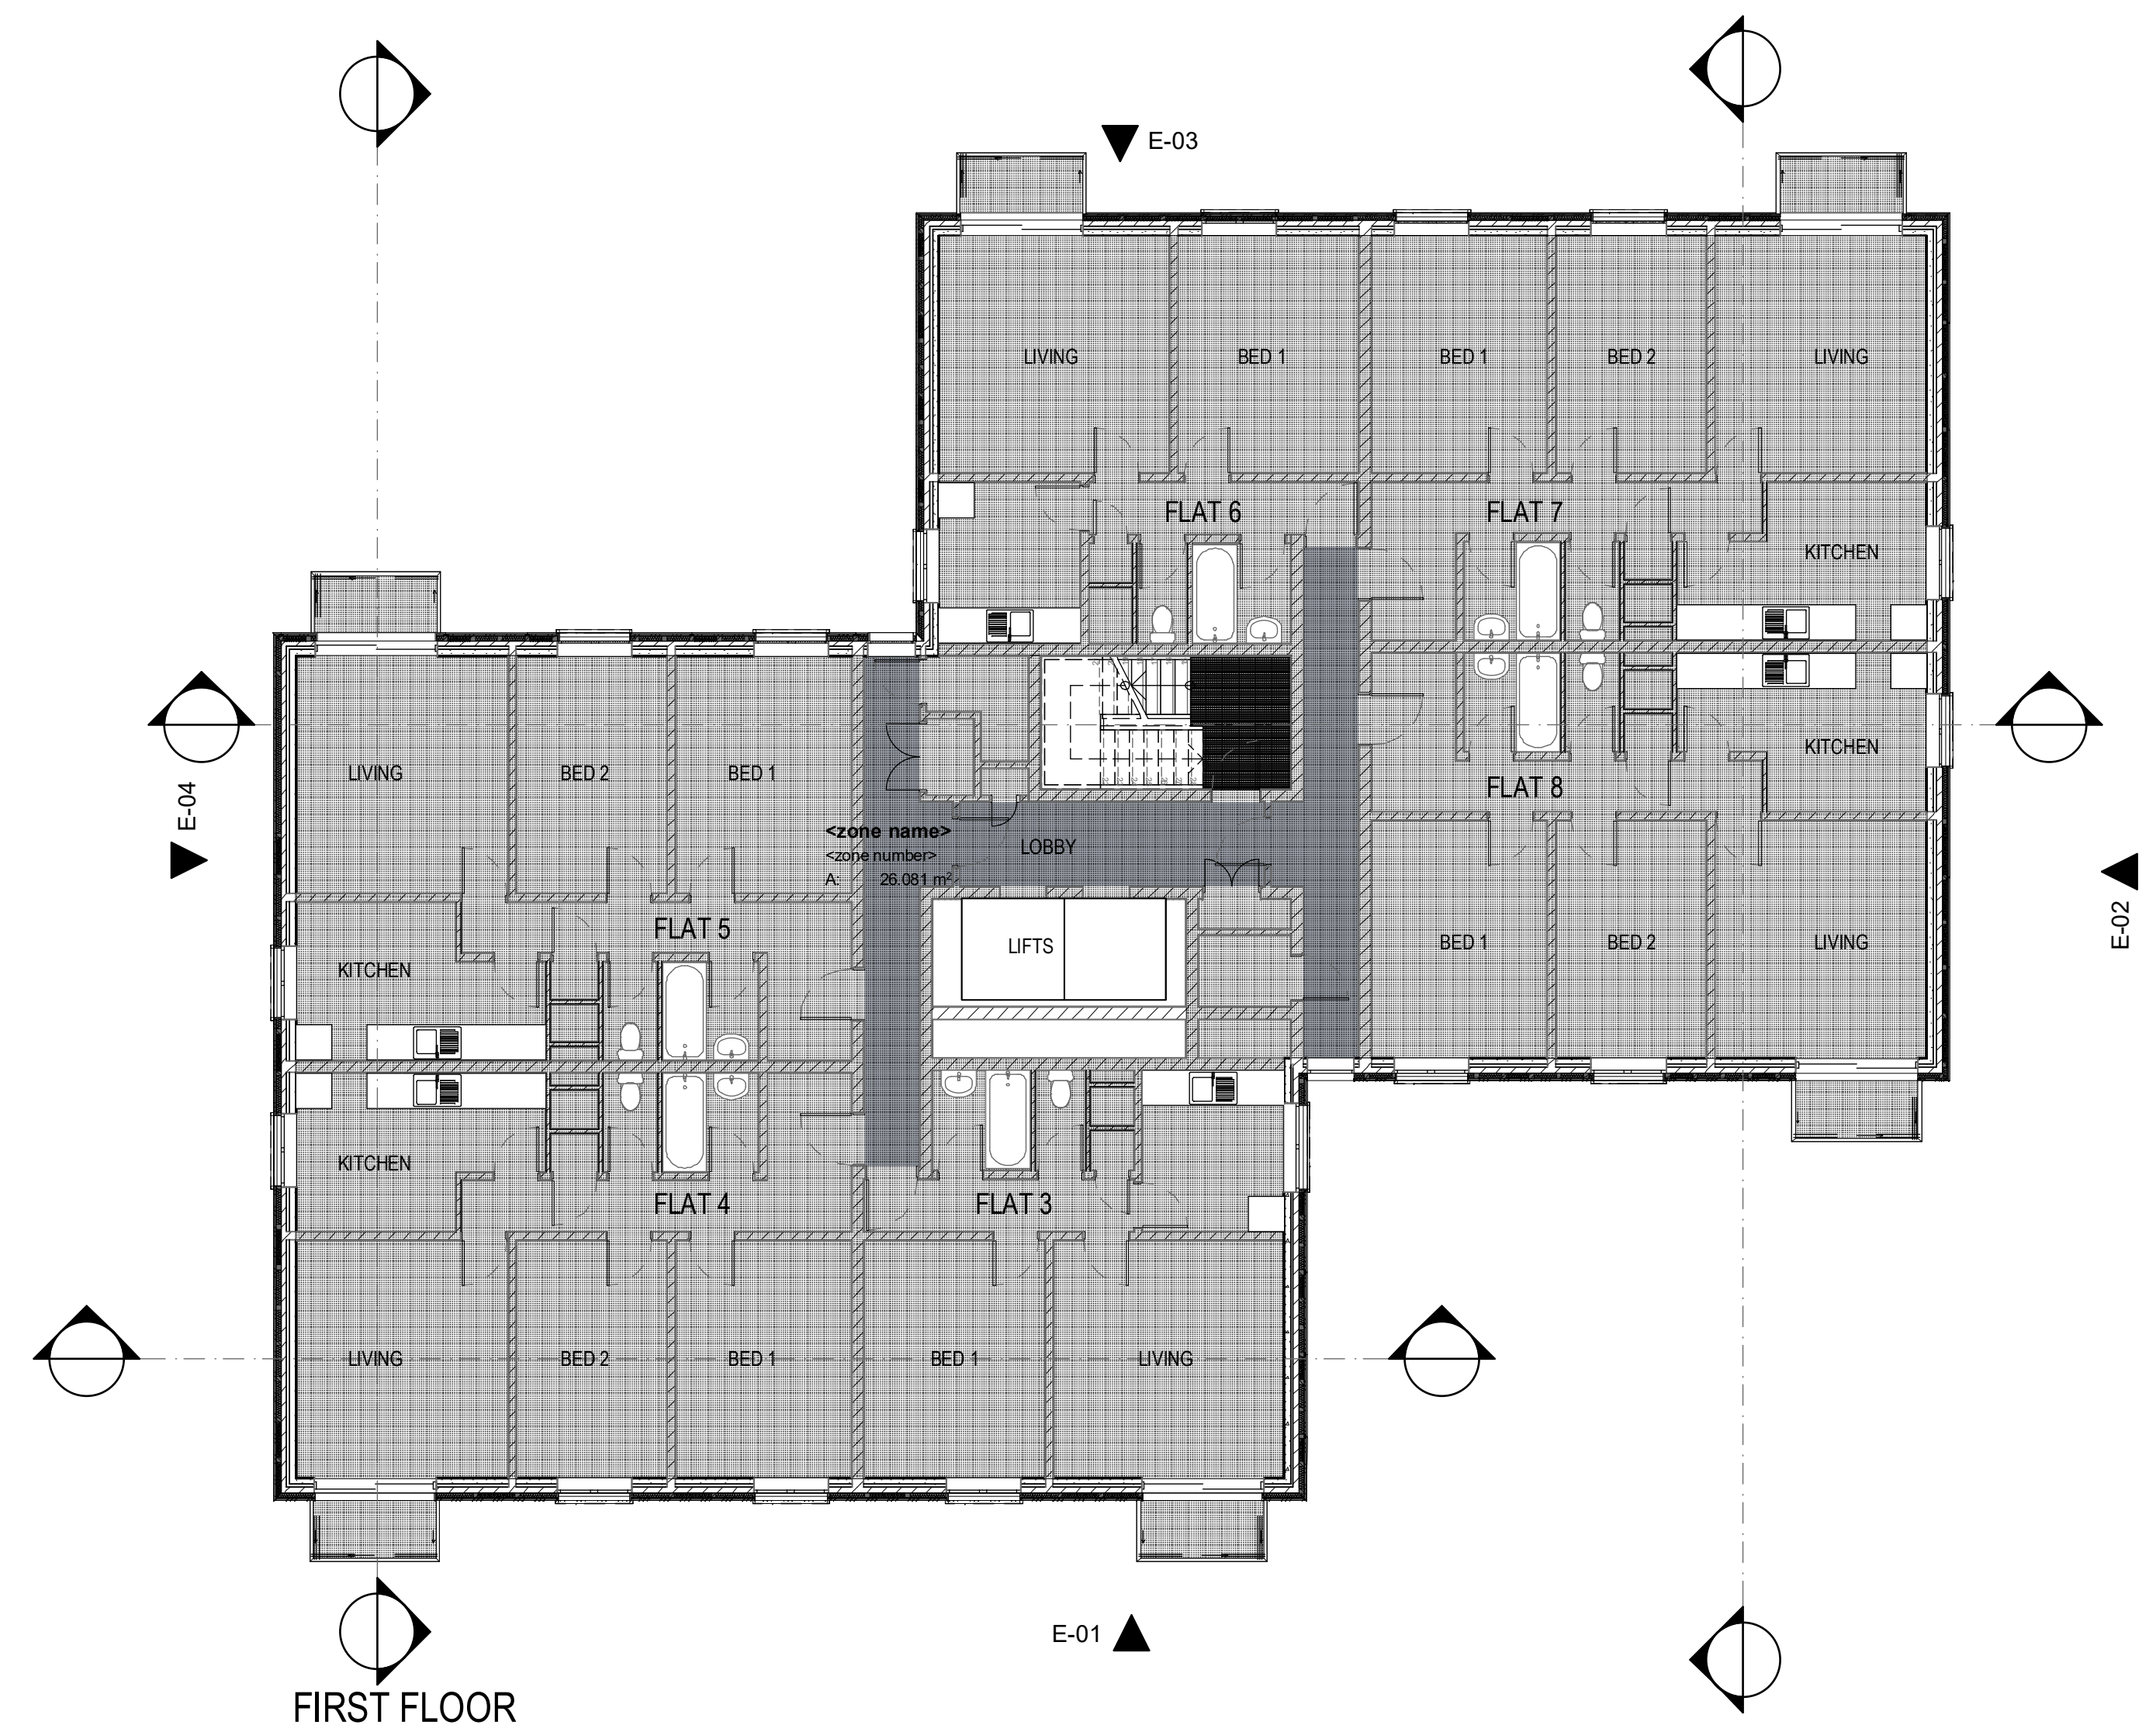


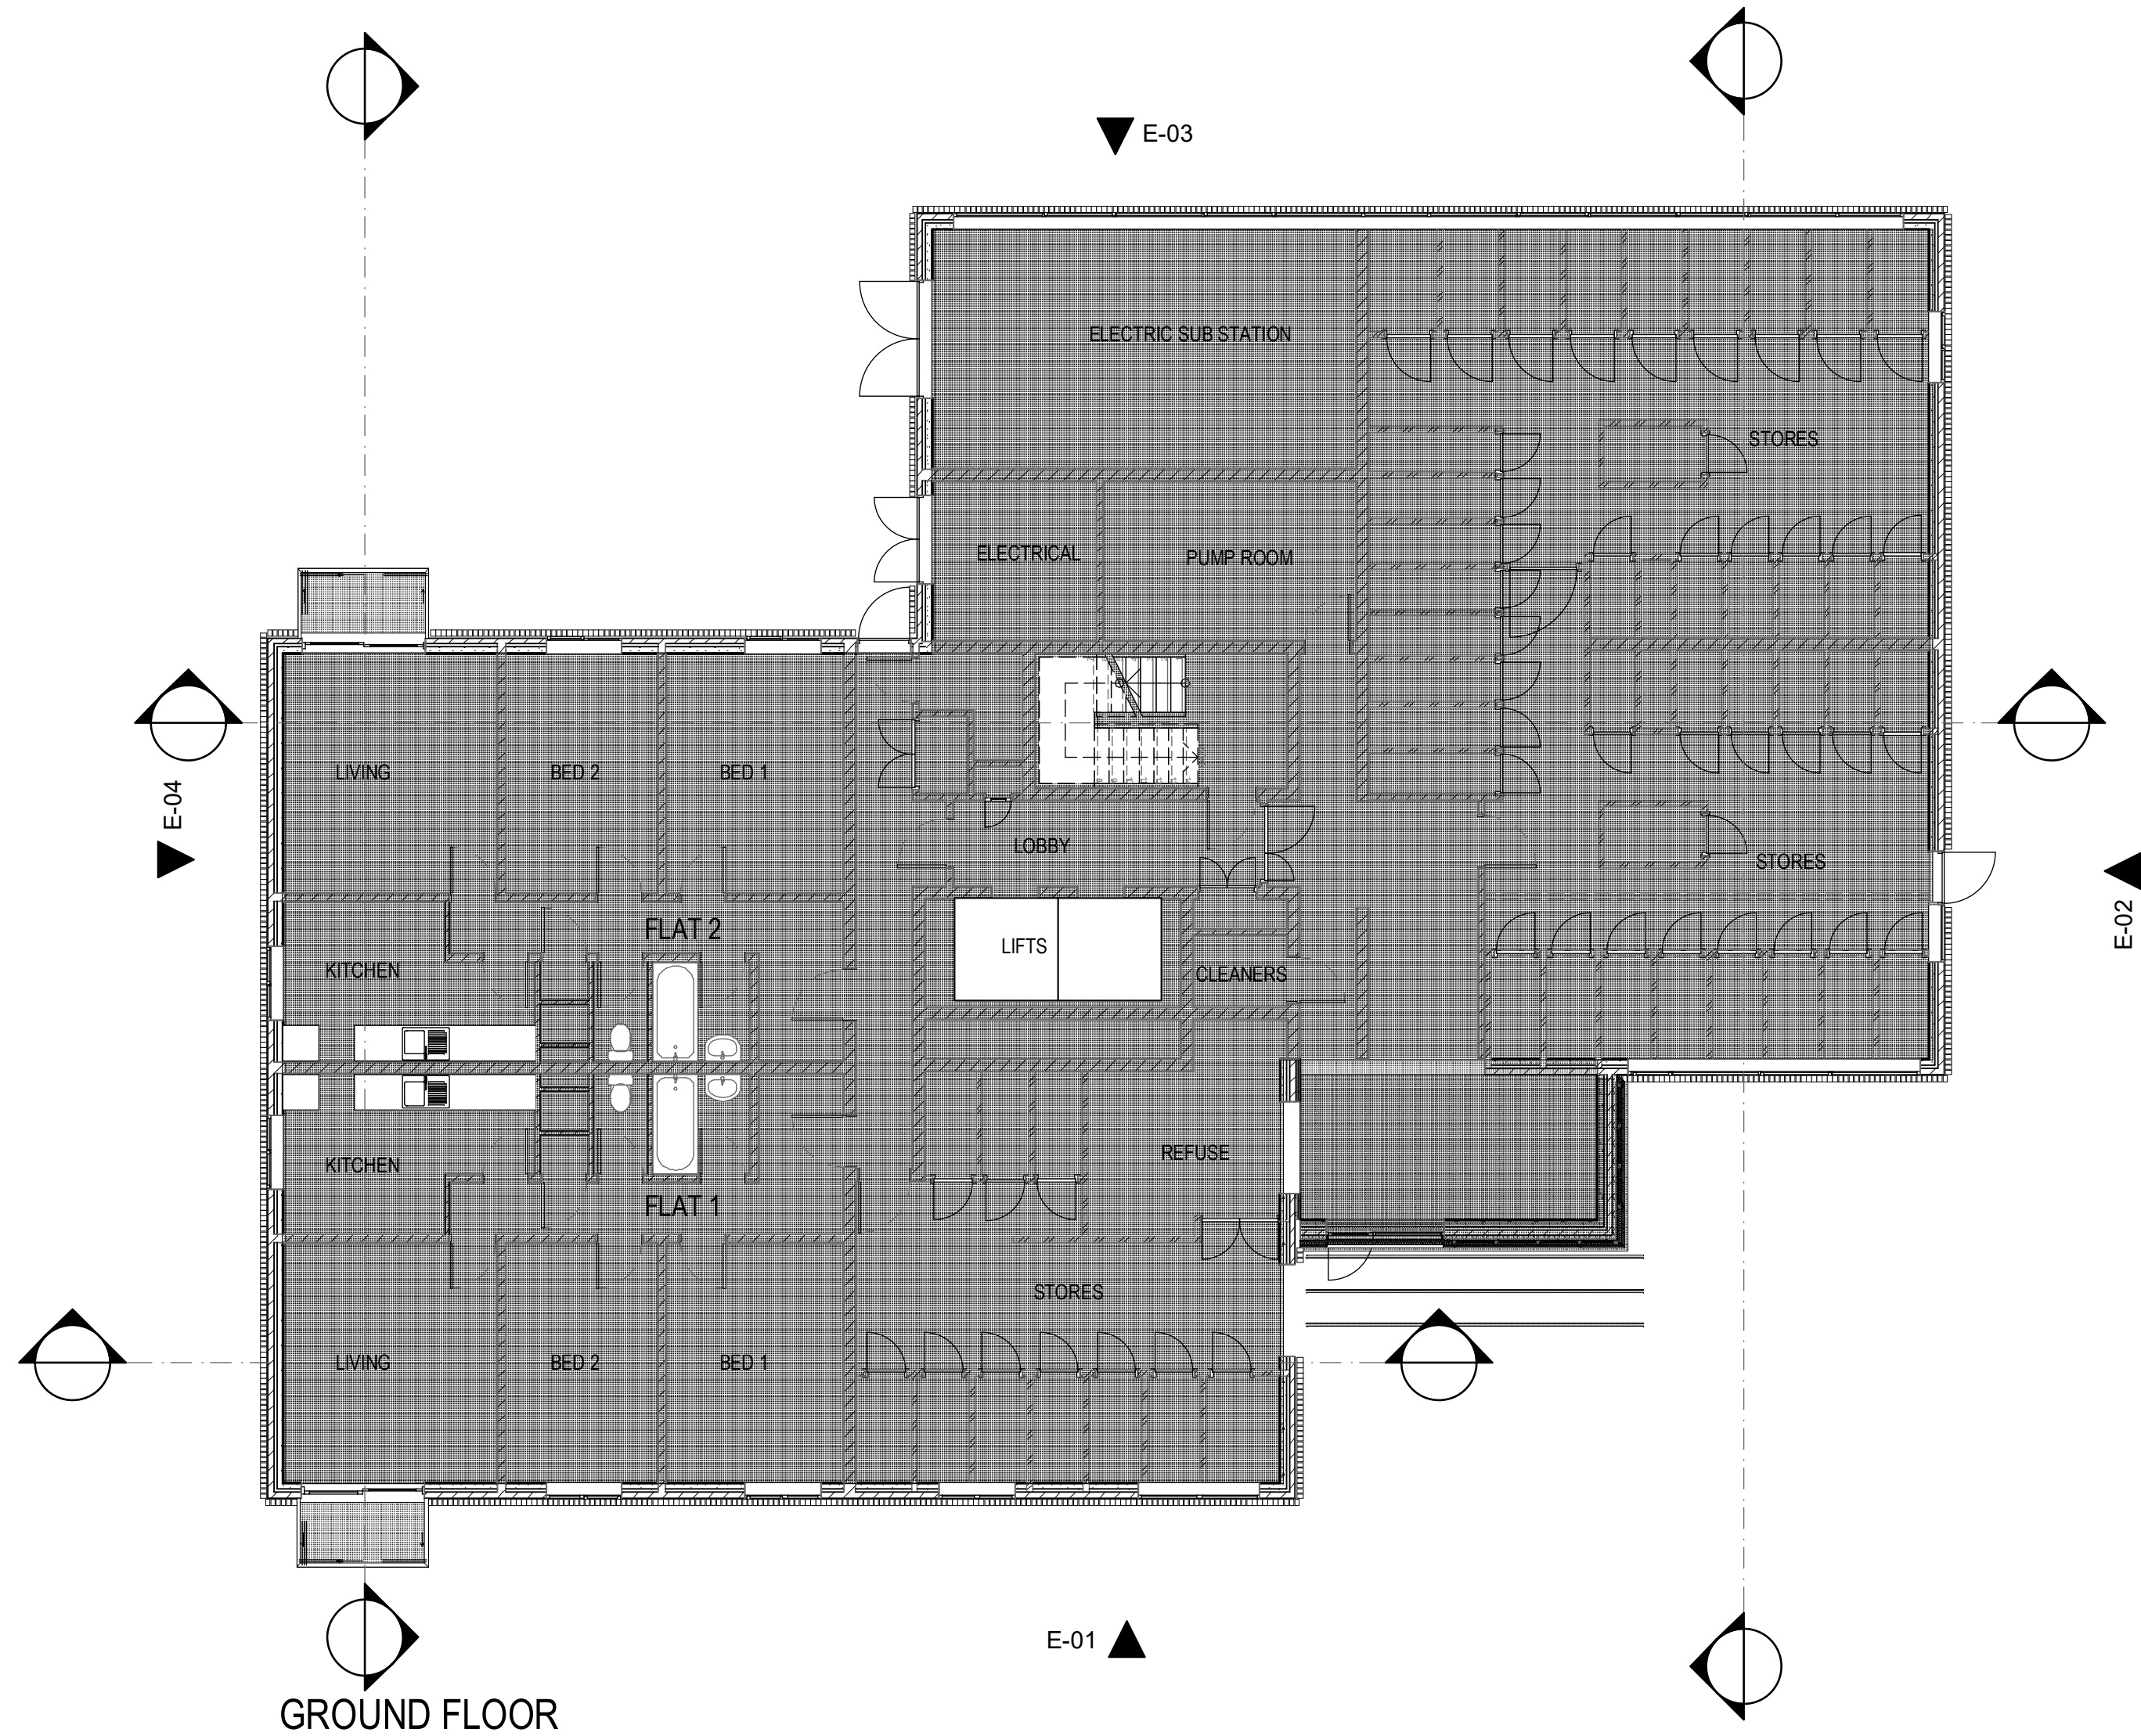

Arcus Consulting LLP
Wakefield 0192 466 9000
Liverpool 0151 708 1080
www.arcus.uk.com

Manchester 0161 905 3222
Newcastle 0191 280 4000
info@arcus.uk.com

London 020 8742 2512
info@arcus.uk.com

Client
POOLE HOUSING PARTNERSHIP

Project
PROJECT ADMIRAL
POOLE

Title
RODNEY COURT
PROPOSED GROUND & FIRST FLOOR PLAN

Scale	Date	Stage
1:100 @ A1	06/06/18	2
Job No	Drawing No	Rev
5131	Sk 30.025	-
Drawn	Approved	
PDS		

This drawing is the copyright of Arcus. Contractors must check all dimensions on site. Do not scale the drawings. Only figured dimensions are to be worked to.