


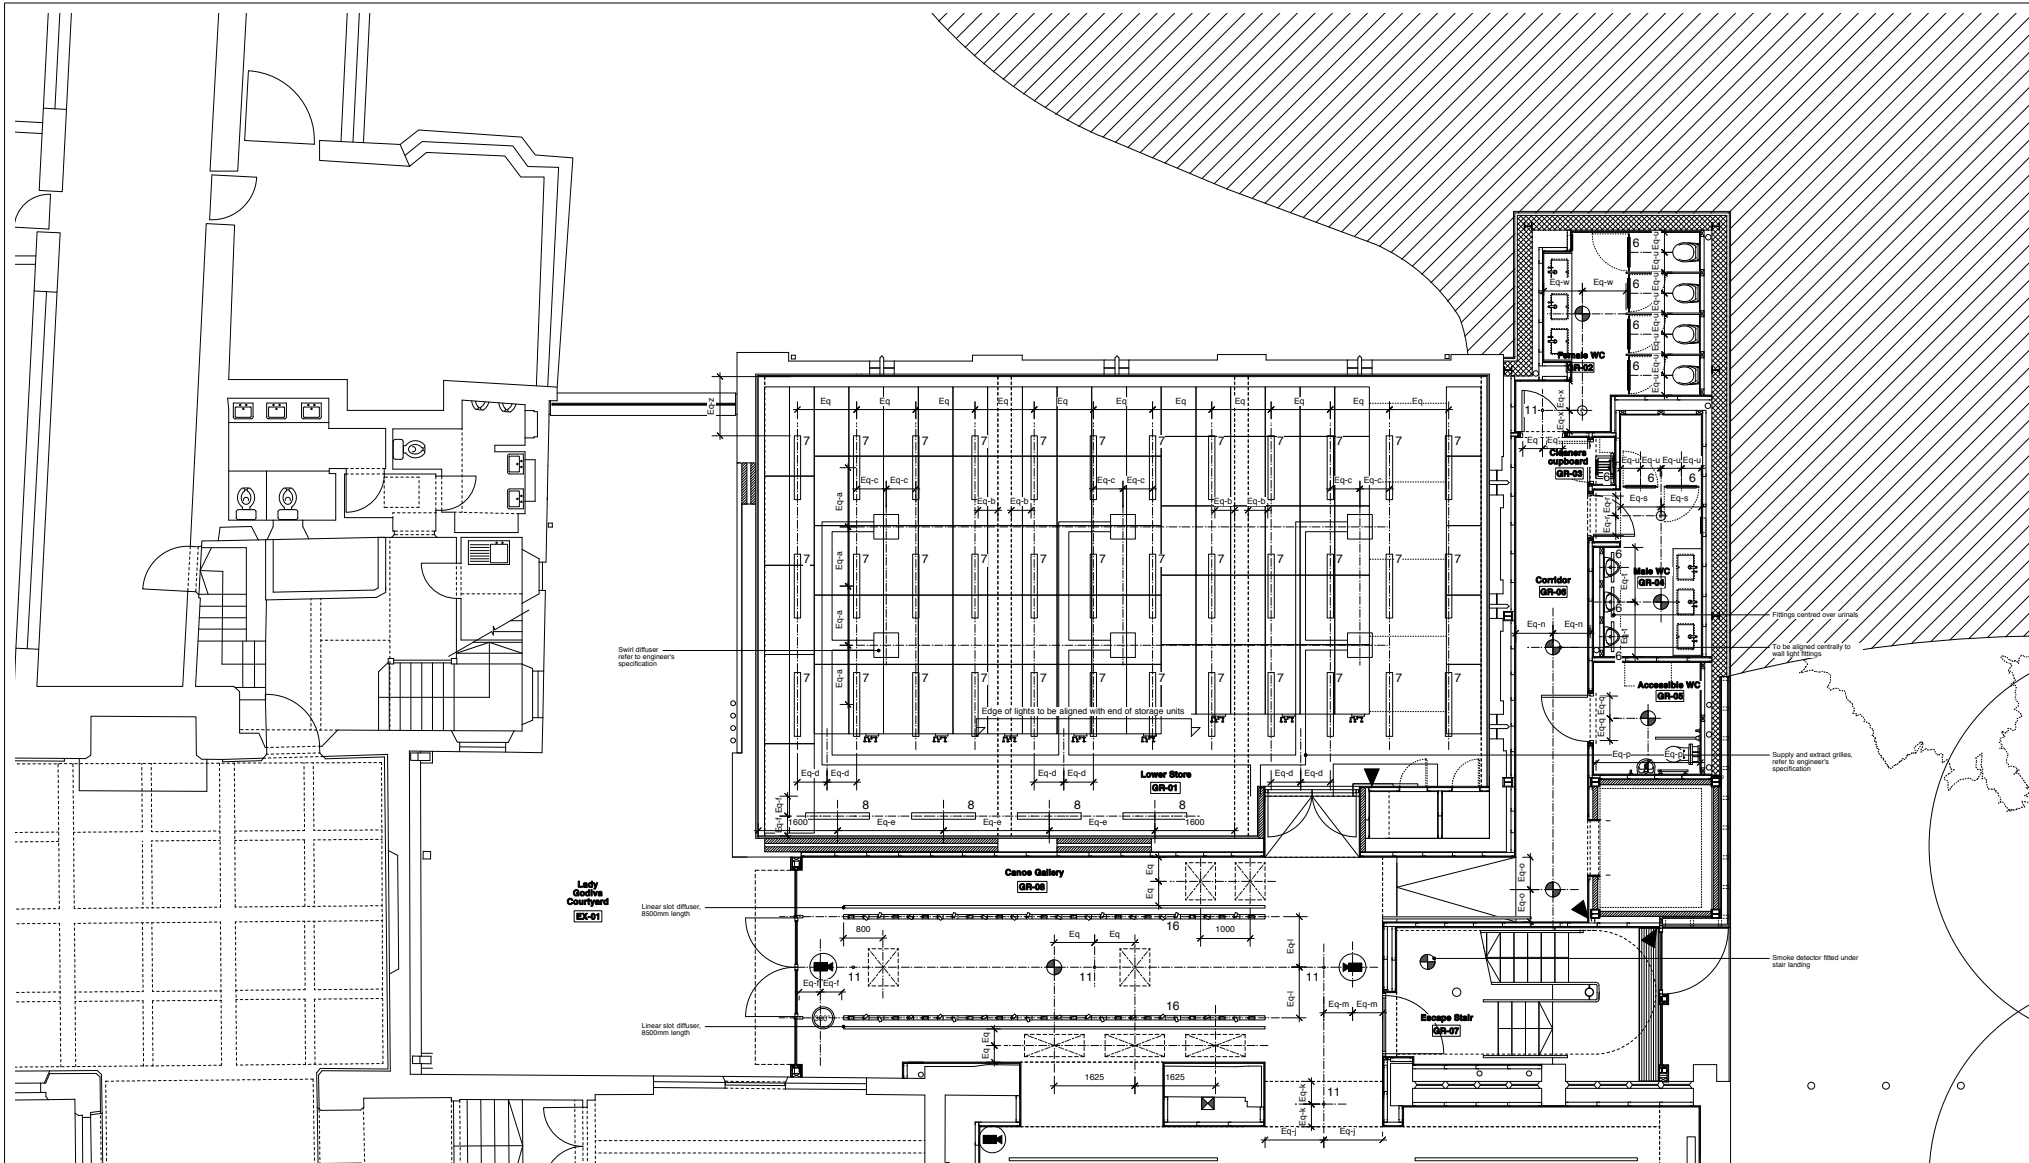

Do not scale drawings
All dimensions are in millimetres unless stated otherwise
Use figured dimensions only and report any discrepancies in writing to the architect

Key

- Smoke detector
- Heat detector
- Dual-tec sensor
- Ceiling mounted camera
- 360° detector
- Presence detector


W Wall mounted wireless access point

C Ceiling mounted wireless access point

Ceiling access panel

Ceiling access panel within perforated ceiling

- Key to lights (refer to M&E specification)
- 1A Plaster-in linear light, length 5000mm, width 60mm
 - 1B OMITTED
 - 1C Plaster-in linear light, length 4200mm, width 60mm
 - 2 Linear continuous fluorescent with 3D offset, suspended 1000mm off FCL
 - 3 Trimless adjustable downlight
 - 4 To be confirmed
 - 5 Square plaster-in light, 150mm square
 - 6 Ceiling mounted fluorescent luminaire
 - 7 Surface mounted fluorescent batten
 - 8 Suspended fluorescent batten
 - 9 Wall mounted linear fluorescent fitting (Type L5 - M&E spec), length 1200mm
 - 10 ~~adjustable spotlight~~ - OMITTED
 - 11 Emergency fitting (Type S - M&E spec)
 - 12 Surface mounted linear fluorescent luminaire
 - 13 ~~linear recessed downlight~~ - OMITTED
 - 14 ~~trimless adjustable downlight~~ - OMITTED
 - 15 Track Luminaire System, suspended
 - 16 Track Luminaire System, recessed

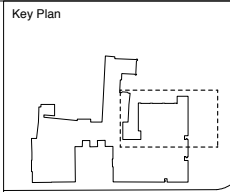

Maidstone Museum & Benthif Art Gallery East Wing Development	
Proposed RC Ground Floor Plan - Zone 2 Status: As Built Scale 1:50	
July 2010	
Draw N° 126/ GA-61	Rev AB
Drawn by: IS	Checked by: GR
Size: A1	
HUGH BROUGHTON ARCHITECTS	
41a Beavor Lane, London W6 9BL	
T 020 8735 9959 F 020 8563 3891 E info@hughbroughtonarchitects.co.uk	
AB As Built Issue	GR 10/10/11
C1 Construction Issue	GR 13/09/10
Rev	Description
Drawn	Date

© Hugh Broughton Architects