

- LEGEND
- 

13amp SWITCHED FUSED SPUR
- 

AS ABOVE BUT CEILING MOUNTED
- 

DOUBLE SOCKET OUTLET
- 

2No. DOUBLE SOCKET OUTLETS
- 

SINGLE SOCKET OUTLET
- 

13 Amp SWITCHED FUSED SPUR WITH SINGLE SOCKET OUTLET
- 

DOUBLE SOCKET OUTLET
- 

2 or 3 COMPARTMENT GALV/STEEL TRUNKING at LOW LEVEL
- 

DISTRIBUTION BOARD BY MCM, ALL CIRCUITS TO BE PROTECTED BY RCBO TYPE CIRCUIT BREAKERS, ALLOW FOR 2 SPARE RCBO's per BOARD.
- 

TWIN CAT 6 DATA OUTLET POINT
- 

SWITCHED FUSED FOR EXTRACTOR FAN
- 

HAND DRYER, SPS + FLEX OUTLET
- 

H/L HIGH LEVEL

NOTES

These drawings shall be read in conjunction with the Electrical Specification by Rosiek Ltd

The contractor will be required to visit site prior to the submission of their tender documents. No additional costs will be accepted due to the contractors failure to carry out the specified pre-tender survey. All items shown or noted on these drawings together with the specification shall be included within the tendered sum

The contractor shall note that each office space and adjacent W/C shall be feed via the local distribution board in that area. Common areas such as stair wells landings entrance hall shall be supplied from the Landlords board.

All existing containment shall be stripped out. The contractor shall supply and install a galvanised steel containment system to accommodate the complete smolt power, data and alarm systems.

The containment system shall be complete in all respects, flush/hidden behind new plasterboard ceilings/portions or surface mounted to existing brickwork or concrete

Power and data point shall rise up from the low level trunking to desk height in galvanised steel conduit

Before any materials are ordered or installation work commenced, the contractor shall put forward their containment proposals for discussion


The kitchen shall be wired on its own dedicated ring circuit

Fixed electrical equipment shall be wired on dedicated radial circuits per item

The LV riser and the 2No. ELV risers shall be fully furnished from top to bottom with Galvanised cable tray

The data installation shall be carried out by others, however the contractor shall allow for all necessary holes and containment from the cabinets to the final accessories

The Fire Alarm installation shall be carried out by others, however the contractor shall allow for all necessary holes and containment.

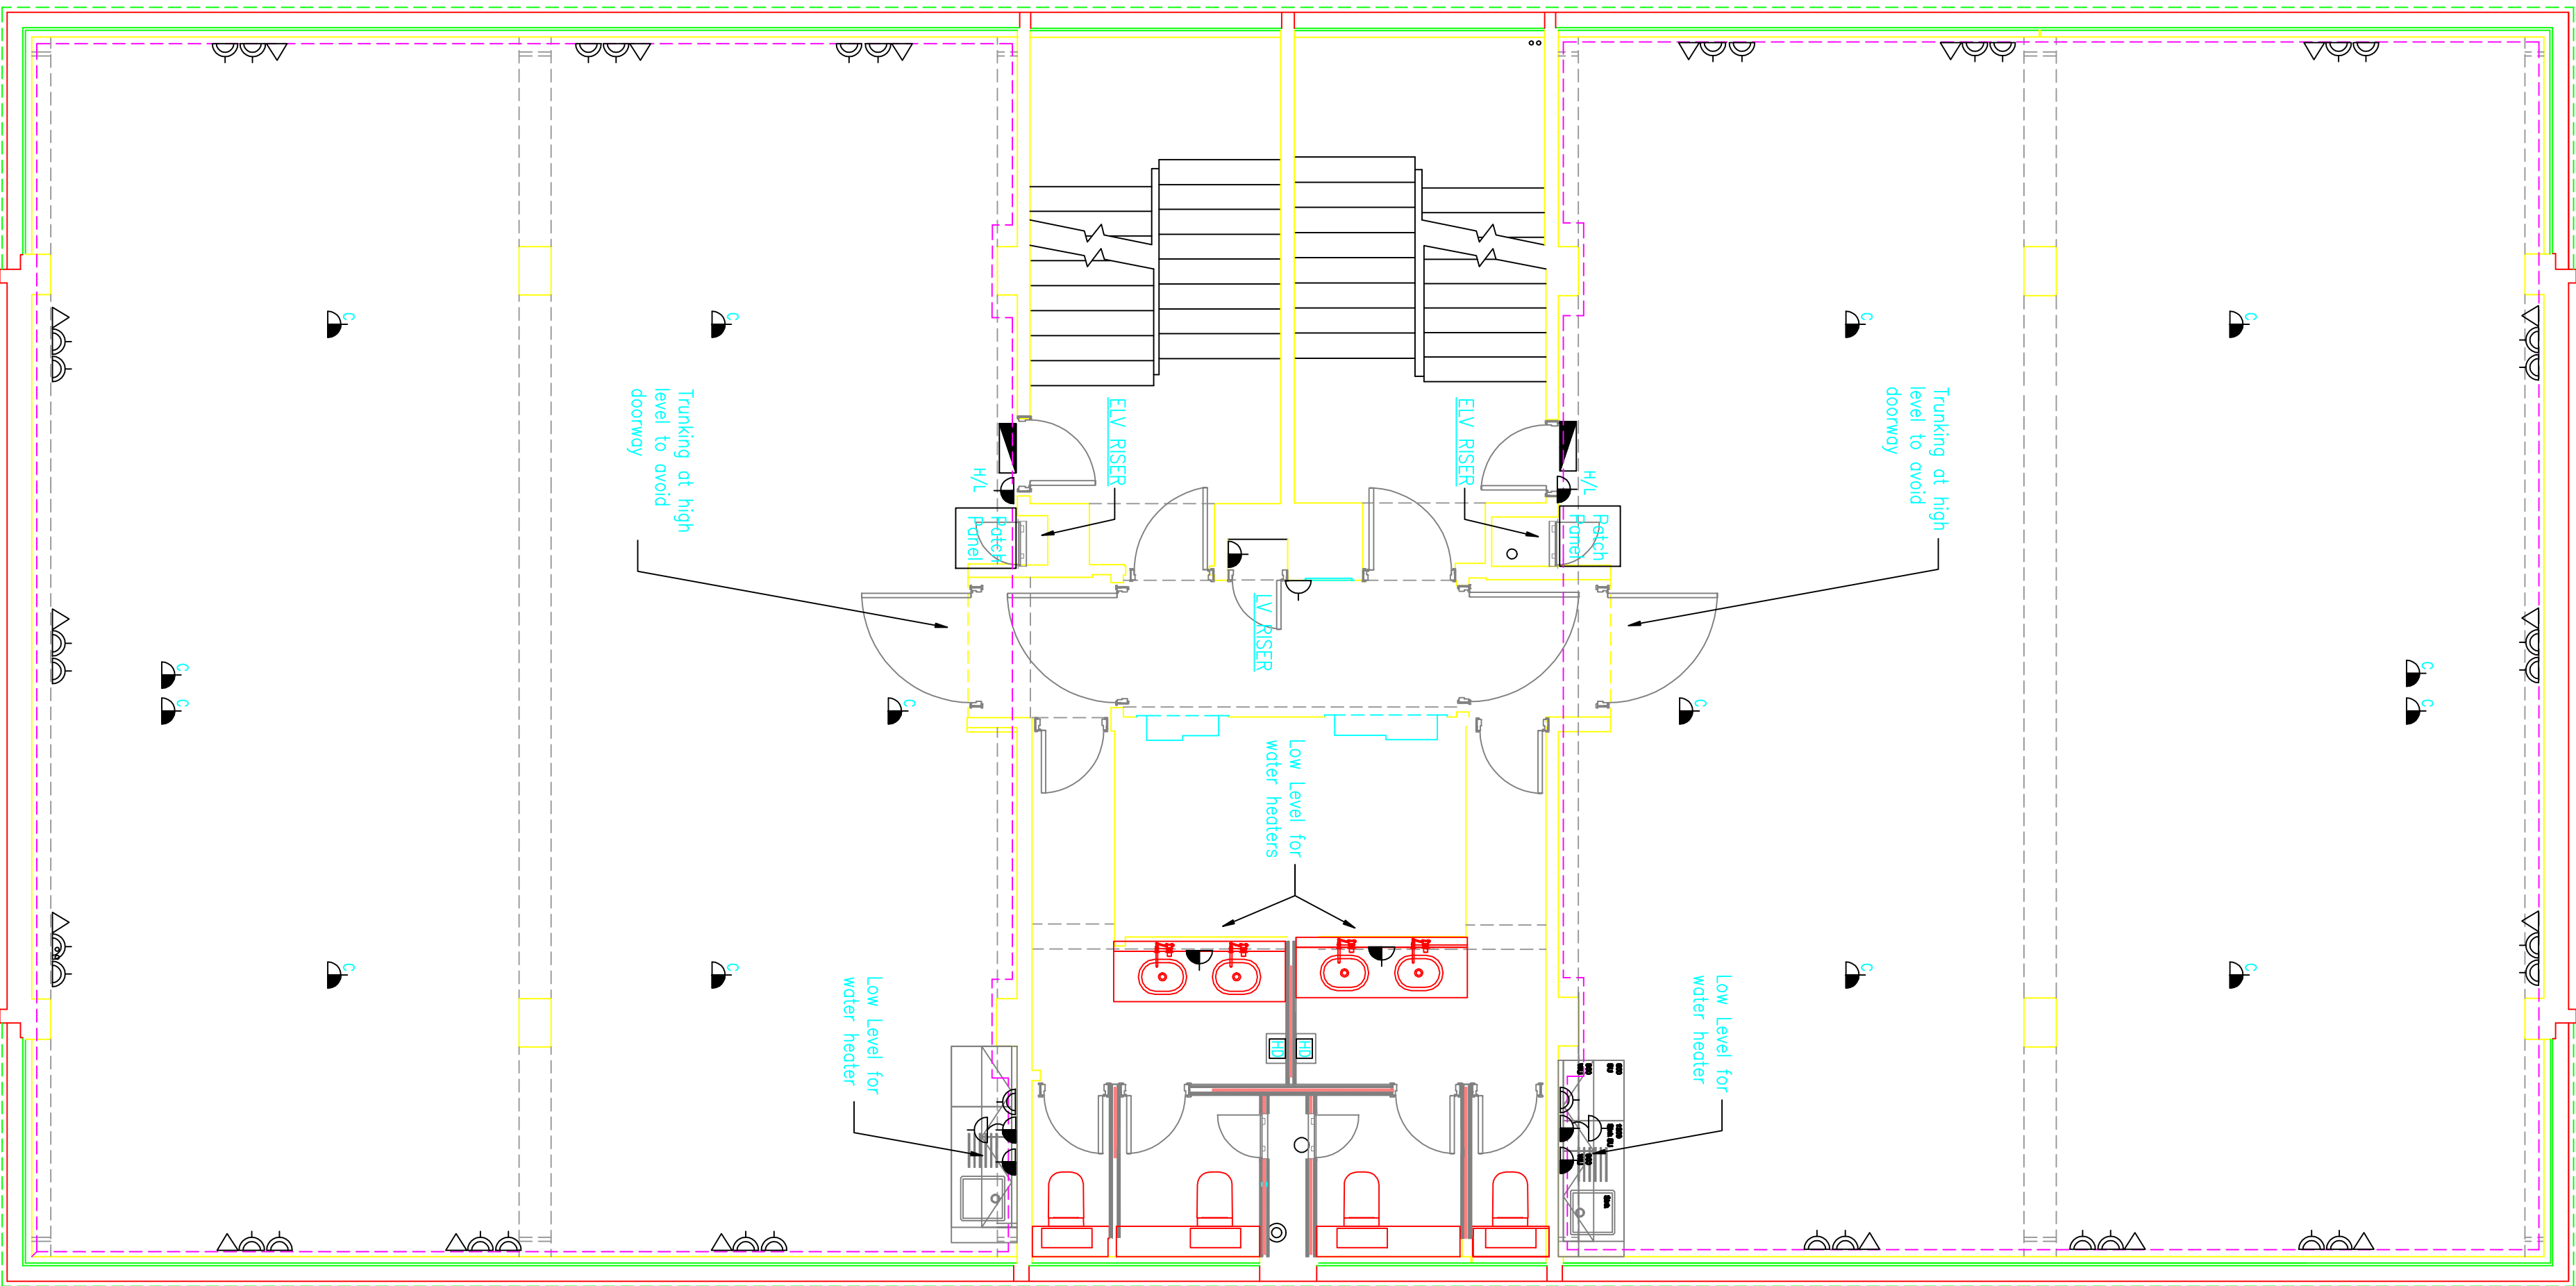

Item#	Quantity	Title/Name, designation, material, dimension etc	Article No./Reference
Designed by Ben Jones	Checked by bj	Approved by - date N/A	Scale 150 @ A1
Rosiek Ltd		Filename Preliminary	Date 04/09/17
Dwg No. 17020-T-207-1		Edition Rev 1	Sheet 1/1

4th Floor Power/Data Layout