
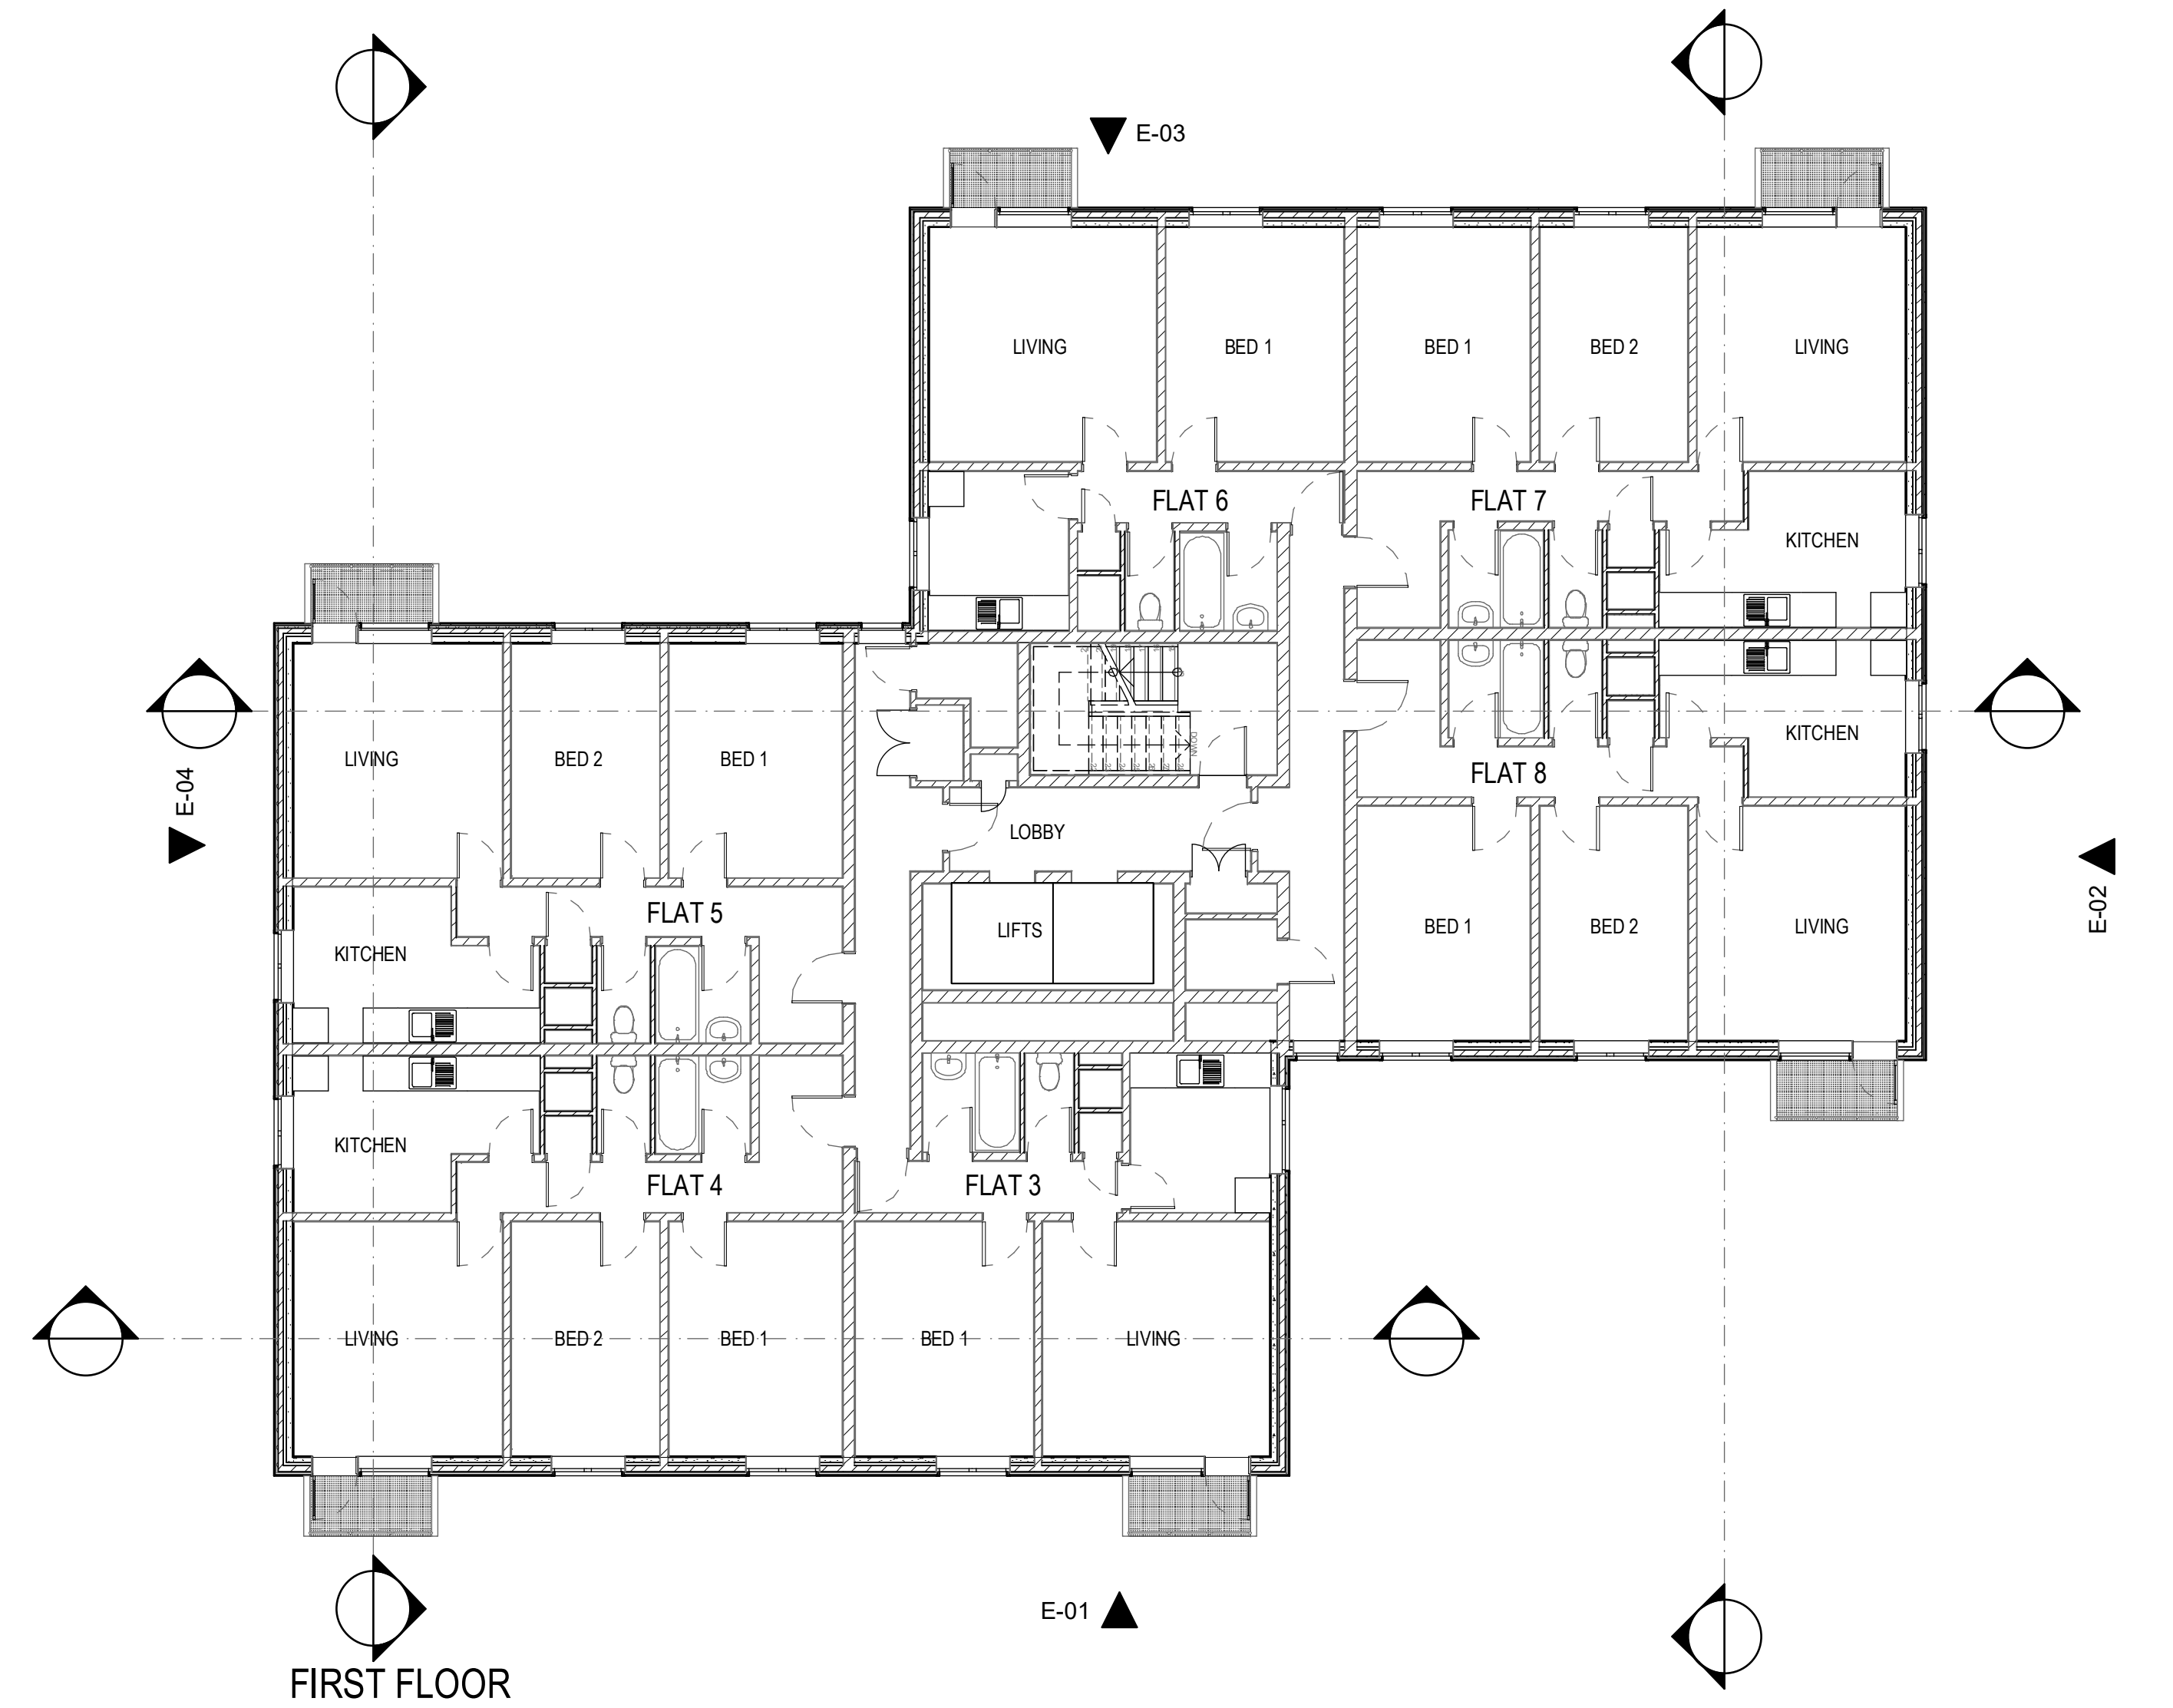


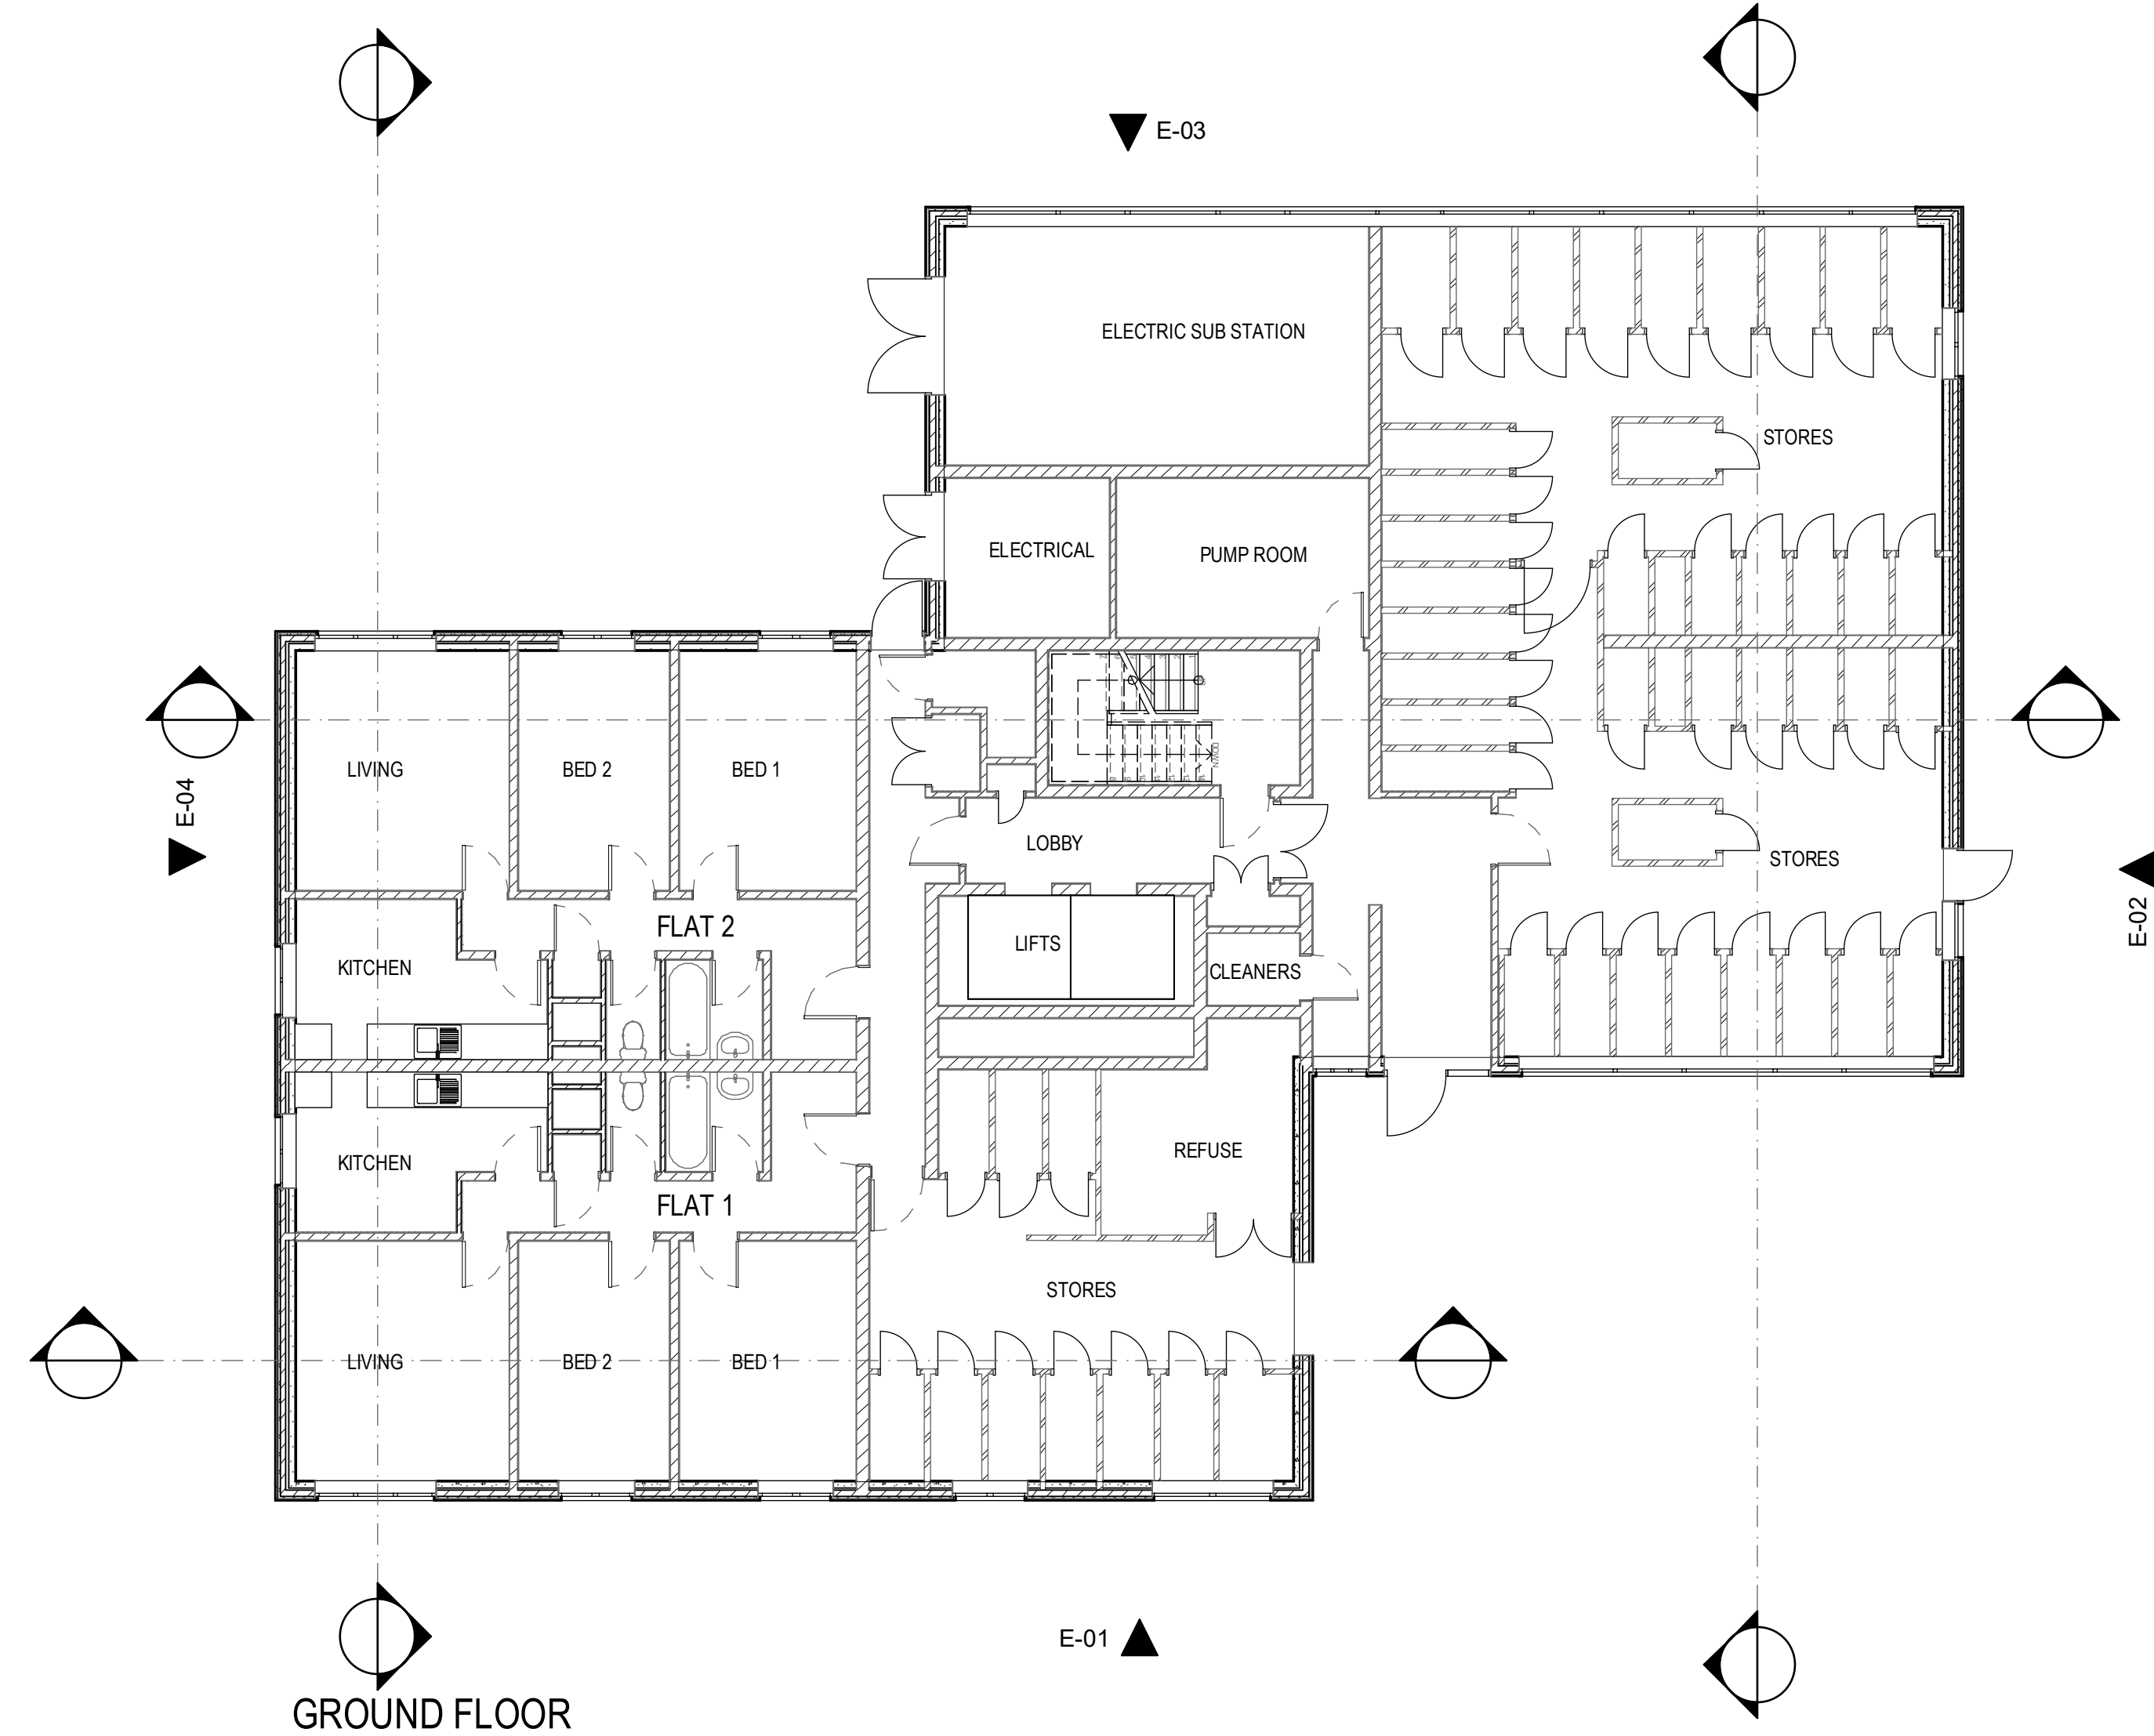

Arcus Consulting LLP
 Wakefield 0192 466 9000
 Liverpool 0151 708 1080
 www.arcus.uk.com

Manchester 0161 905 3222
 Newcastle 0191 280 4000
 info@arcus.uk.com

London 020 8742 2512
 info@arcus.uk.com

Client
 POOLE HOUSING PARTNERSHIP

Project
 PROJECT ADMIRAL
 POOLE

Title
 GRENVILLE COURT
 GROUND & FIRST FLOOR PLAN

Scale	Date	Stage
1:100 @ A1	01/03/18	2
Job No	Drawing No	Rev
5131	Sk 20.009	-
Drawn	Approved	
PDS		

This drawing is the copyright of Arcus. Contractors must check all dimensions on site. Do not scale the drawings. Only figured dimensions are to be worked to.